

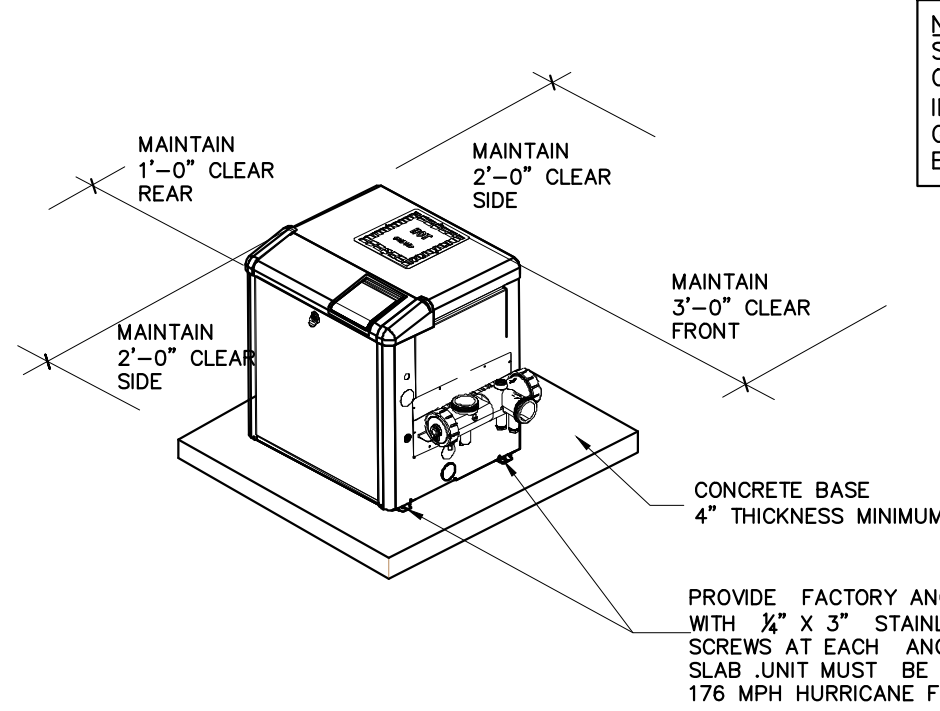


FOR THE PLUMBING NOTES PLEASE REFER TO SHEET "N-01"

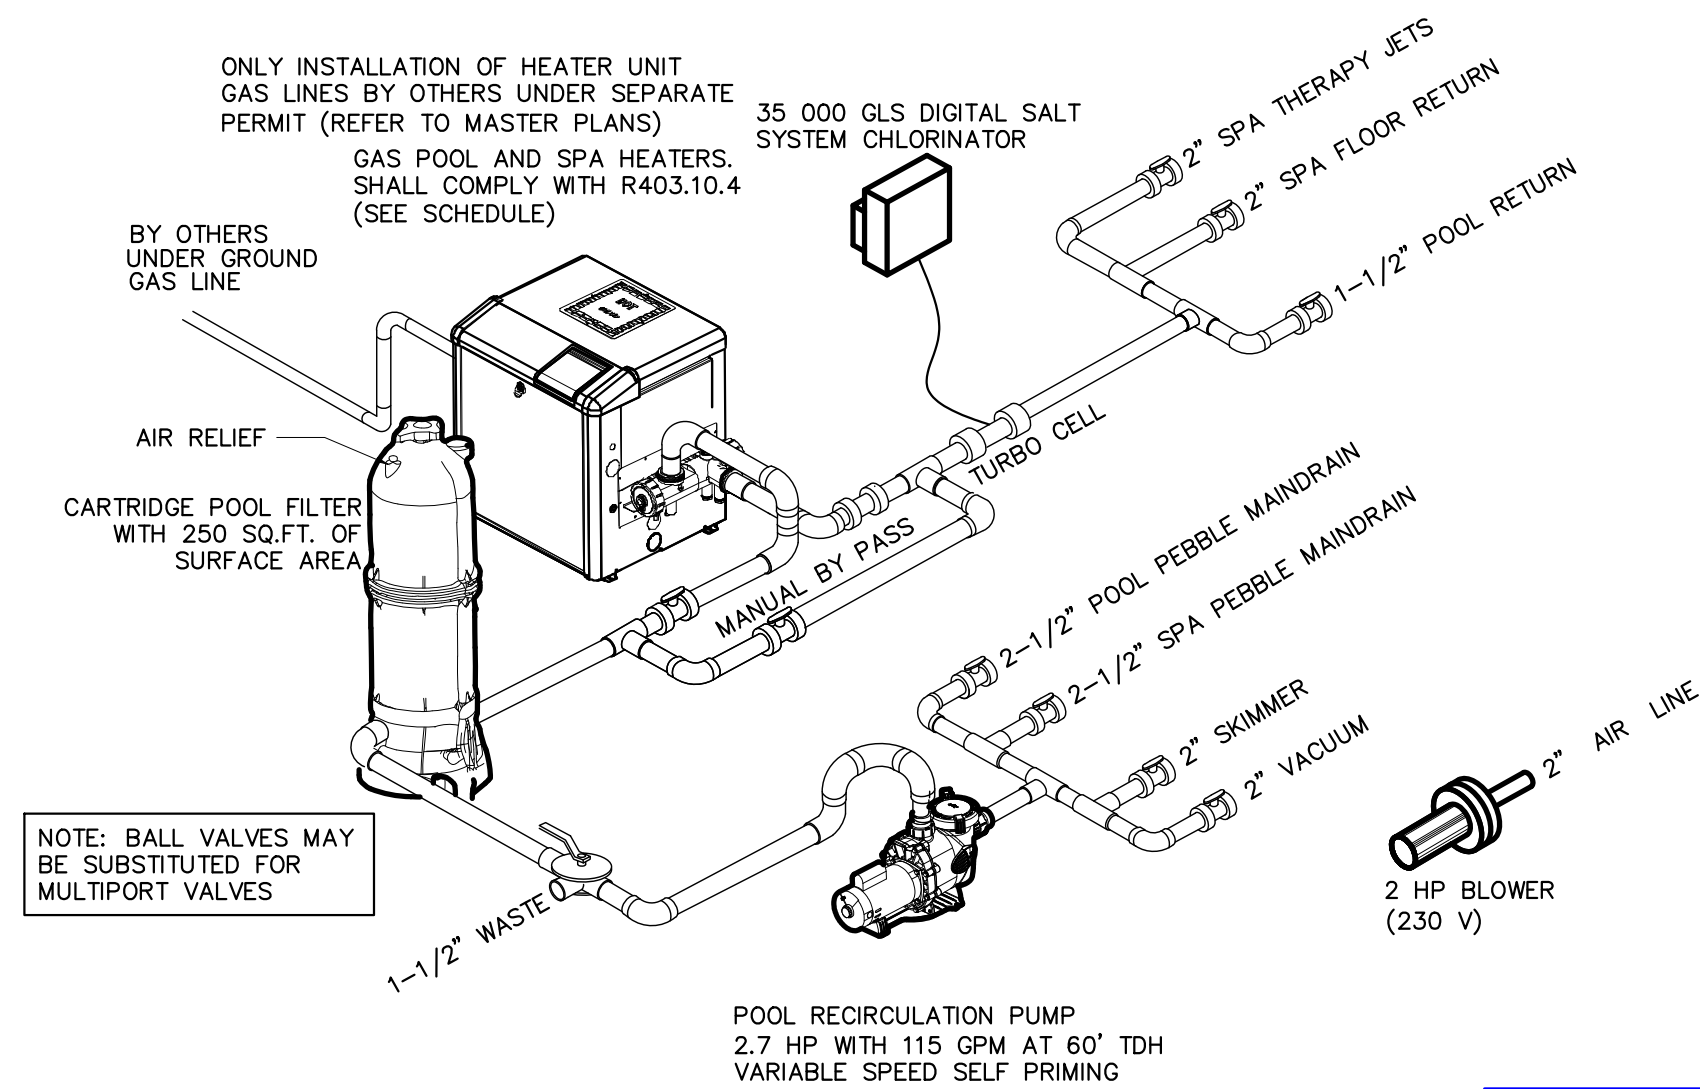

GAS HEATER MOUNTING DETAIL
NO SCALE

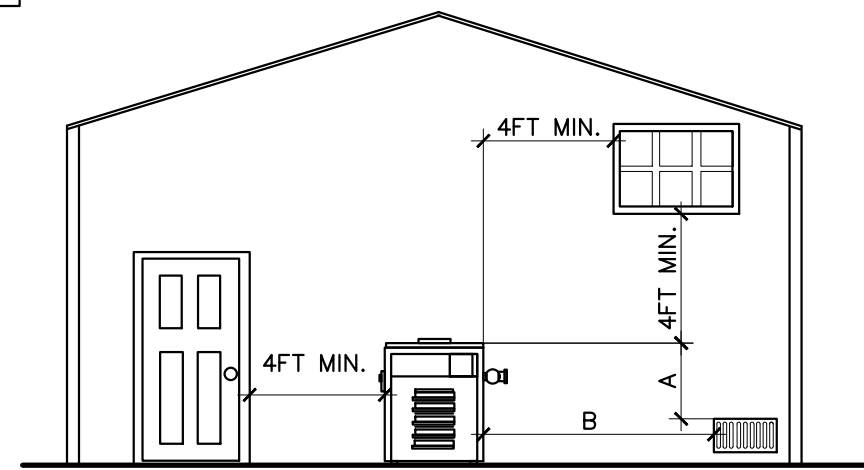


OUTDOOR HEATER INSTALLATION

POOL DATA		
	POOL	SPA
SURFACE AREA (SQFT)	732	64
AVERAGE DEPTH (FT)	4.25	3
VOLUME (GAL)	23,333	1,440
PUMP FLOW (GPM)	115	
TURNOVER (HOUR)	3.38	0.21
PERIMETER (LNFT)	126.00	32
DECK AREA (SQFT)	BY OTHERS 1887	


SYMBOL	NAME	QTY
→	RETURN	4
→	FLOOR RETURN	2
→	THERAPY JET	6
→	VACUUM W/ SPRING LOADED COVER	1
→	SKIMMER	1
→	SUPERFLOW 360 PEBBLE TOP DRAIN	2
→	12W 12V LED NICHELESS LIGHT	7

ISOMETRIC

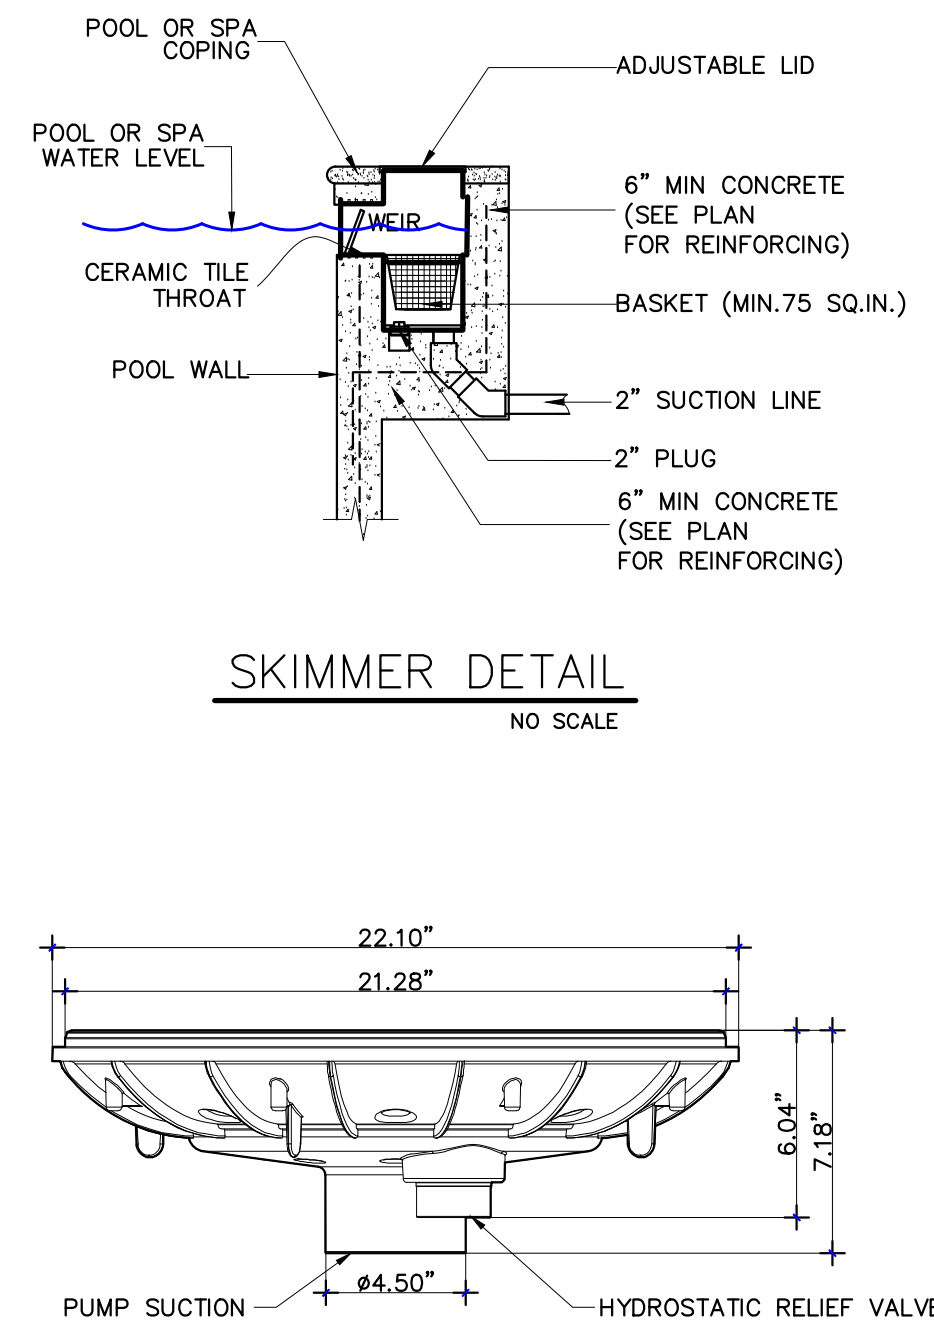

SKIMMER DETAIL
NO SCALE

20"-360° PEBBLE MAINDRAIN DETAIL
NO SCALE

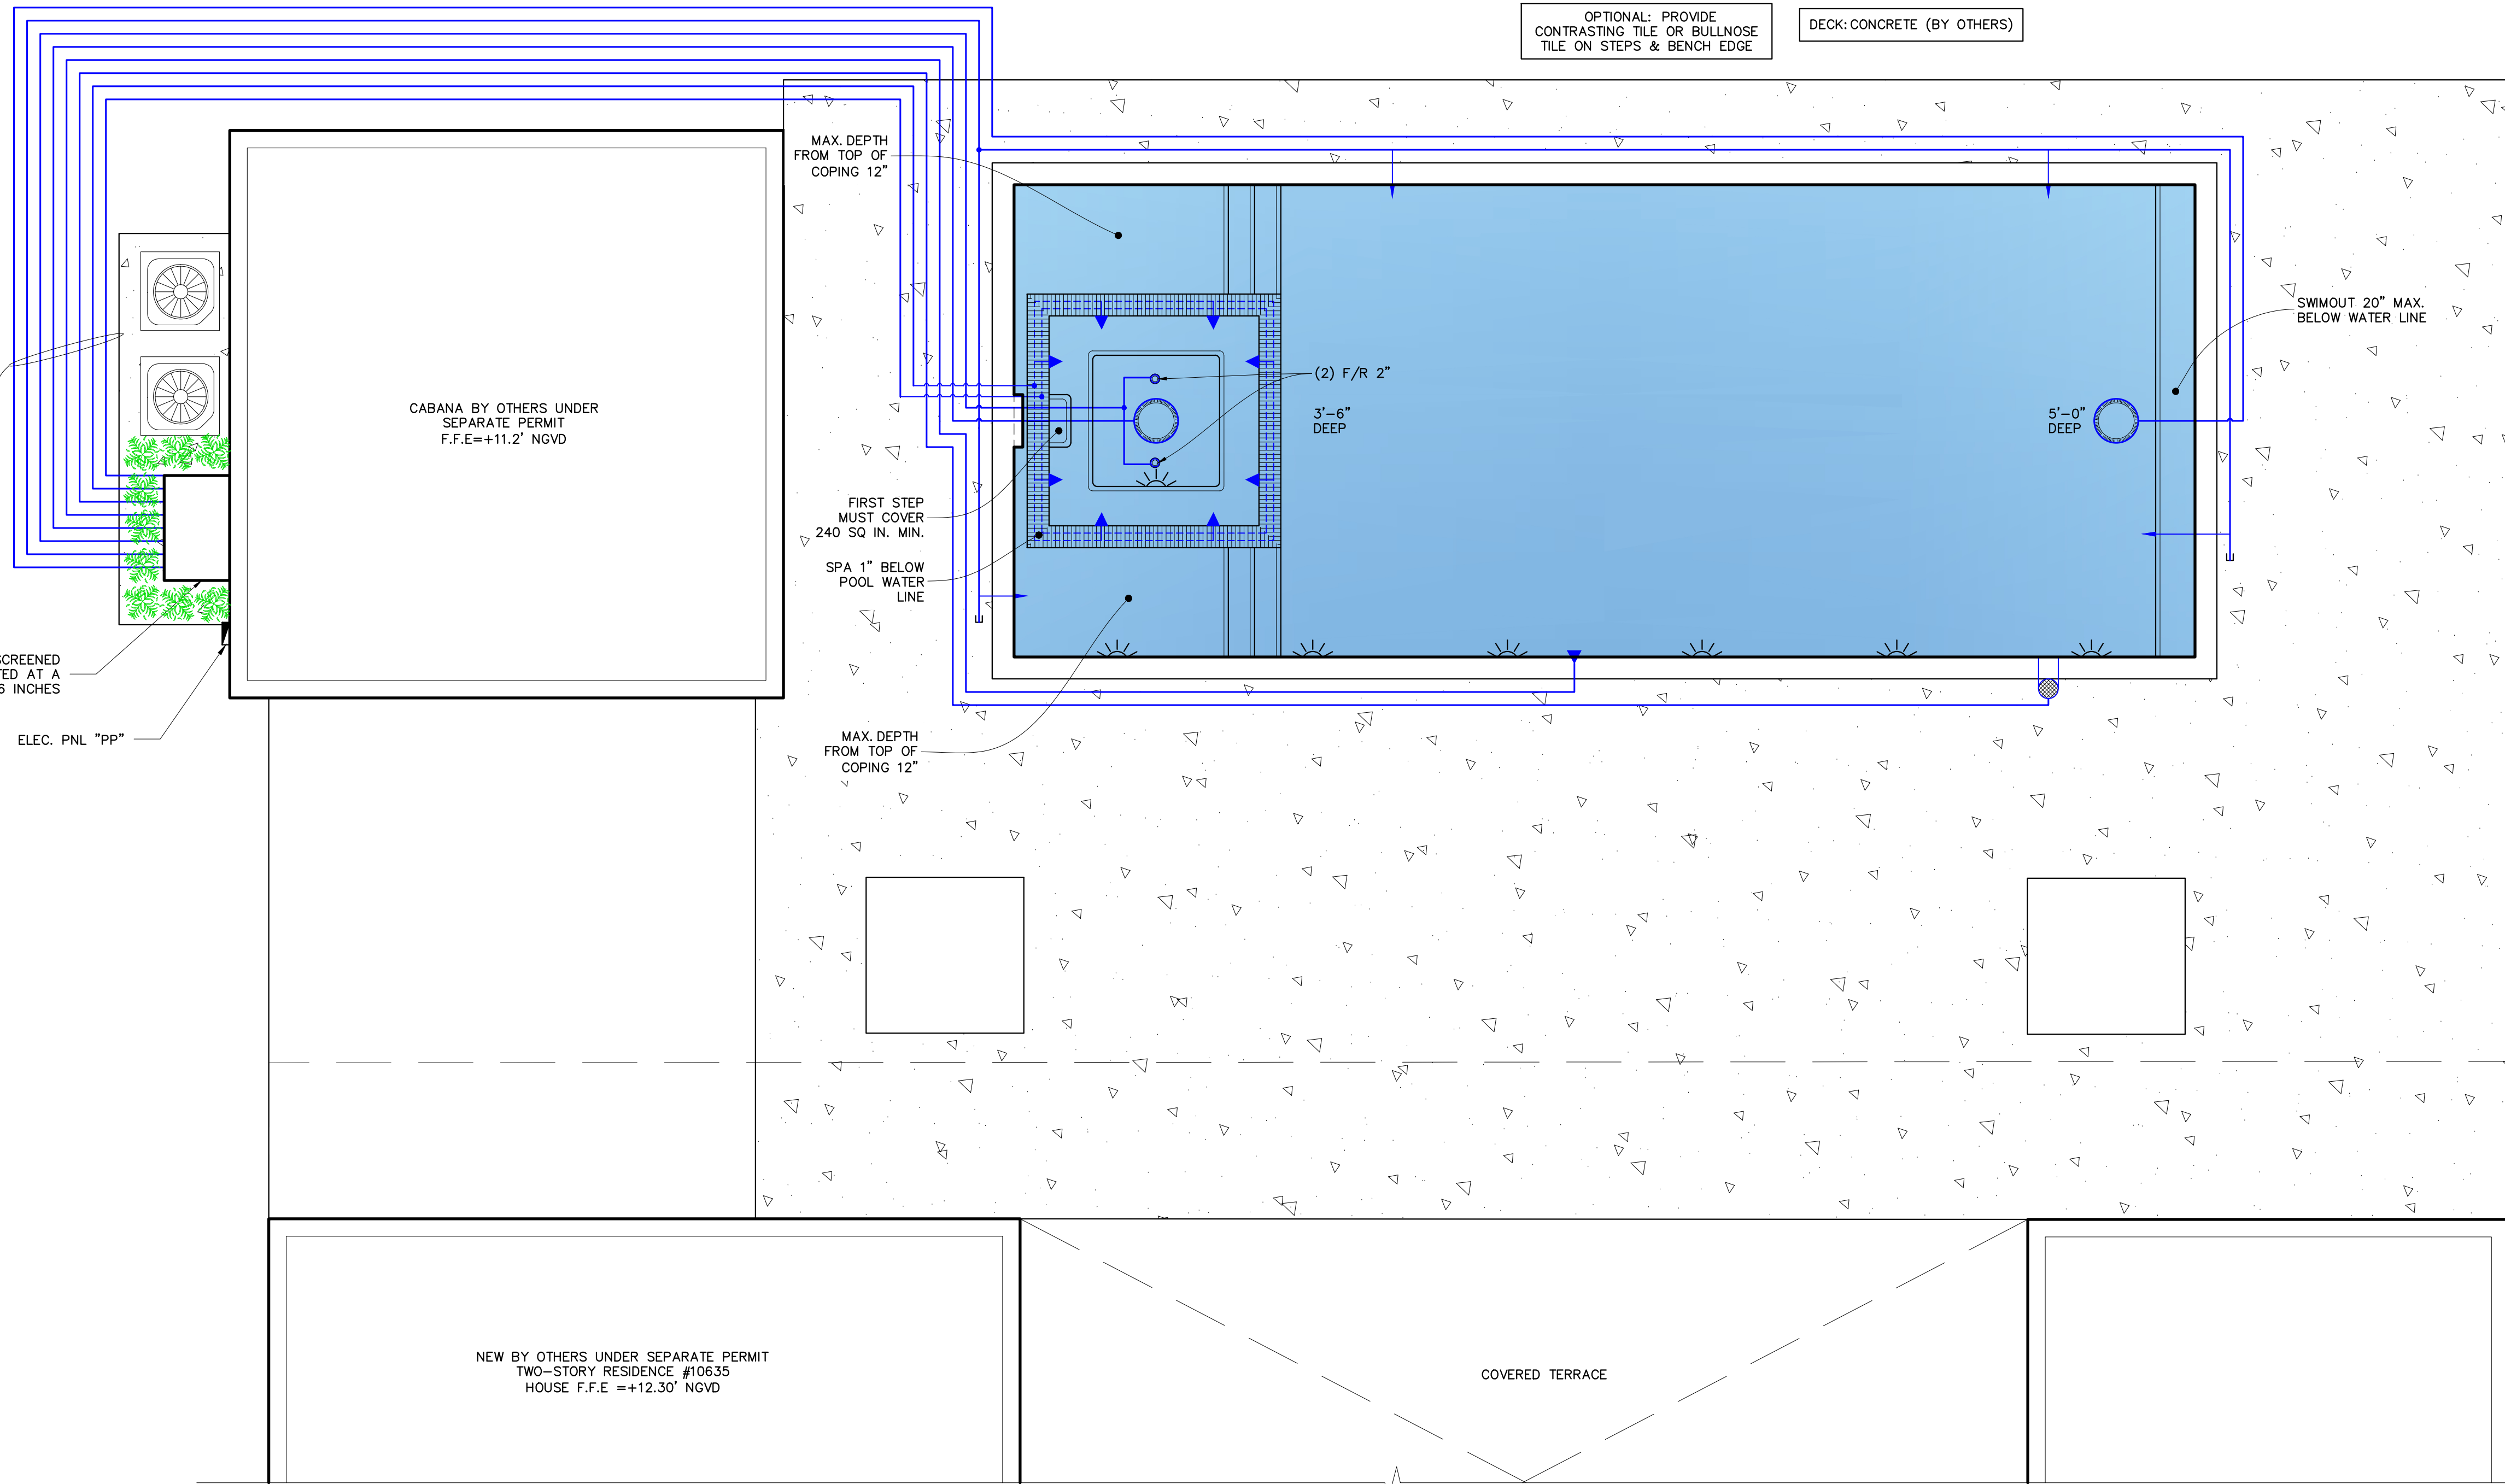

POOL PLUMBING PLAN
SCALE: 1/4"=1'-0"

NOTE: CONTRACTOR SHALL VERIFY ALL SETBACKS FROM
PROPERTY LINES AND STRUCTURES PRIOR TO EXCAVATION.
SHOULD ANY SETBACKS BE LESS THAN THE MINIMUM
REQUIREMENTS, EITHER BY OWNER OR BUILDING OFFICIAL, THE
ENGINEER SHALL BE NOTIFIED.

WARNING: WARNING TO COMPANY OF RECORDS CONSTRUCTION FOR REPAIRS
OR ANY OTHER REPAIRS. REASON: REPAIRS TO BE MADE TO PREVENT PRESSURES
BENEATH THE FLOORING TO BE MAINTAINED TO PREVENT THE
POOL FROM COLLAPSING. FLOWING. UPWARD. REPAIRS TO BE MADE TO PREVENT
AND POOL AND FLOOR COLLAPSE. CONSTRUCTION OF REPAIRS TO BE MADE TO PREVENT
UPLIFT PRESSURES.

THIS ITEM HAS BEEN DIGITALLY SIGNED AND
SEALED
BY JORGE CRESPO ON THE DATE ADJACENT TO
THE SEAL USING A AUTHENTICATION CODE.

PRINTED COPIES OF THIS DOCUMENT ARE NOT
CONSIDERED SIGNED AND SEALED AND THE
AUTHENTICATION CODE MUST BE VERIFIED ON
ANY ELECTRONIC COPIES.