


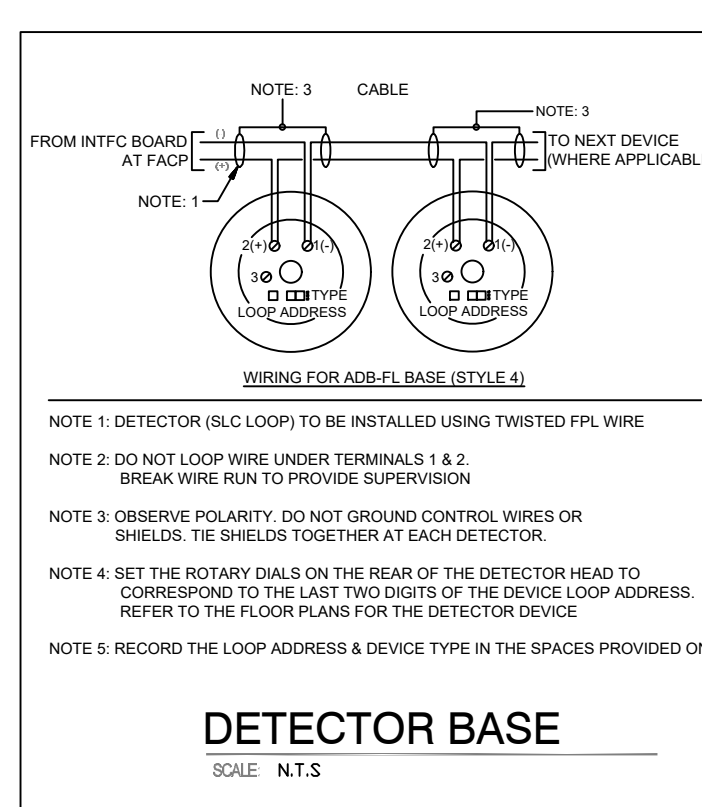
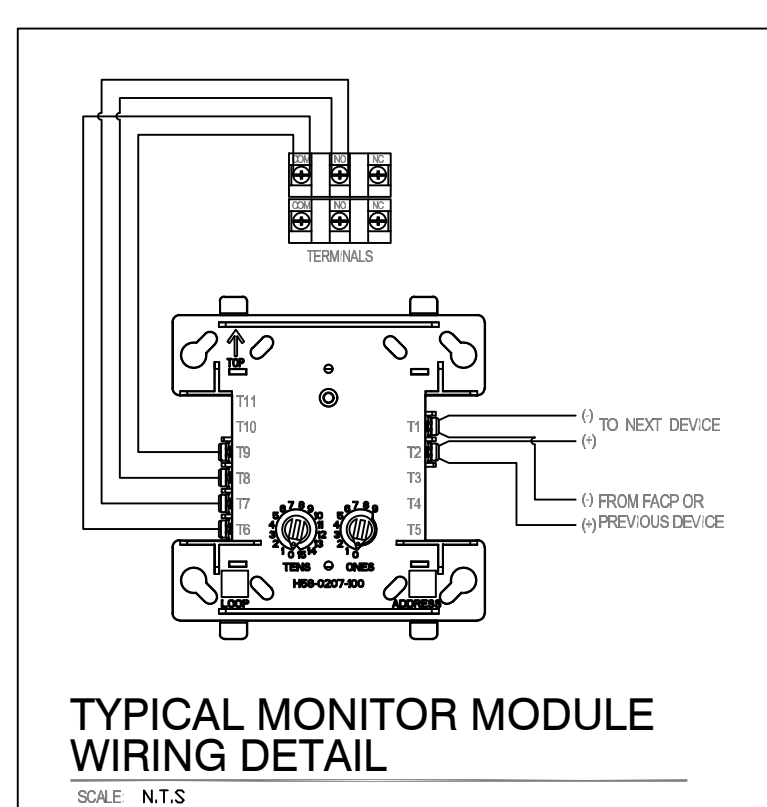
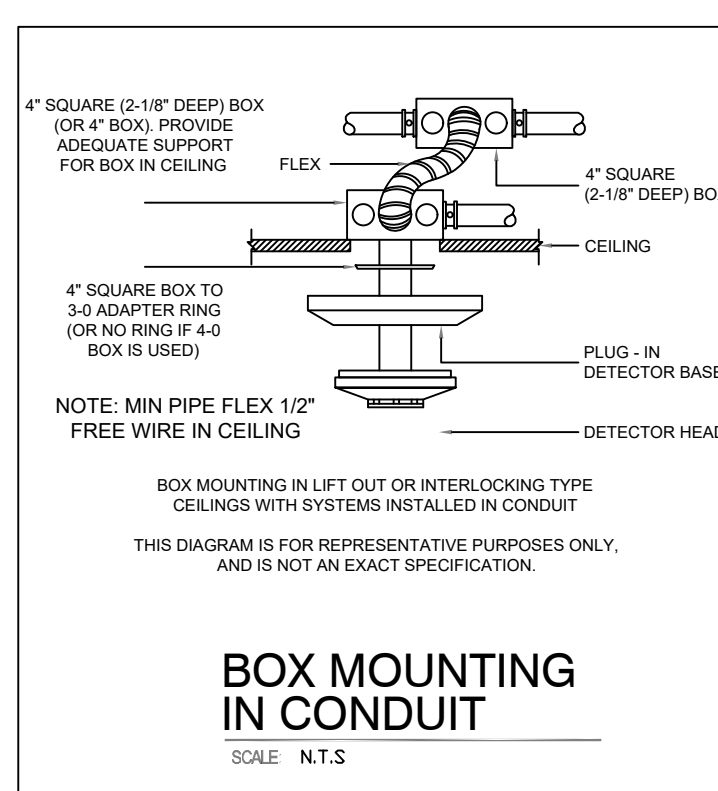
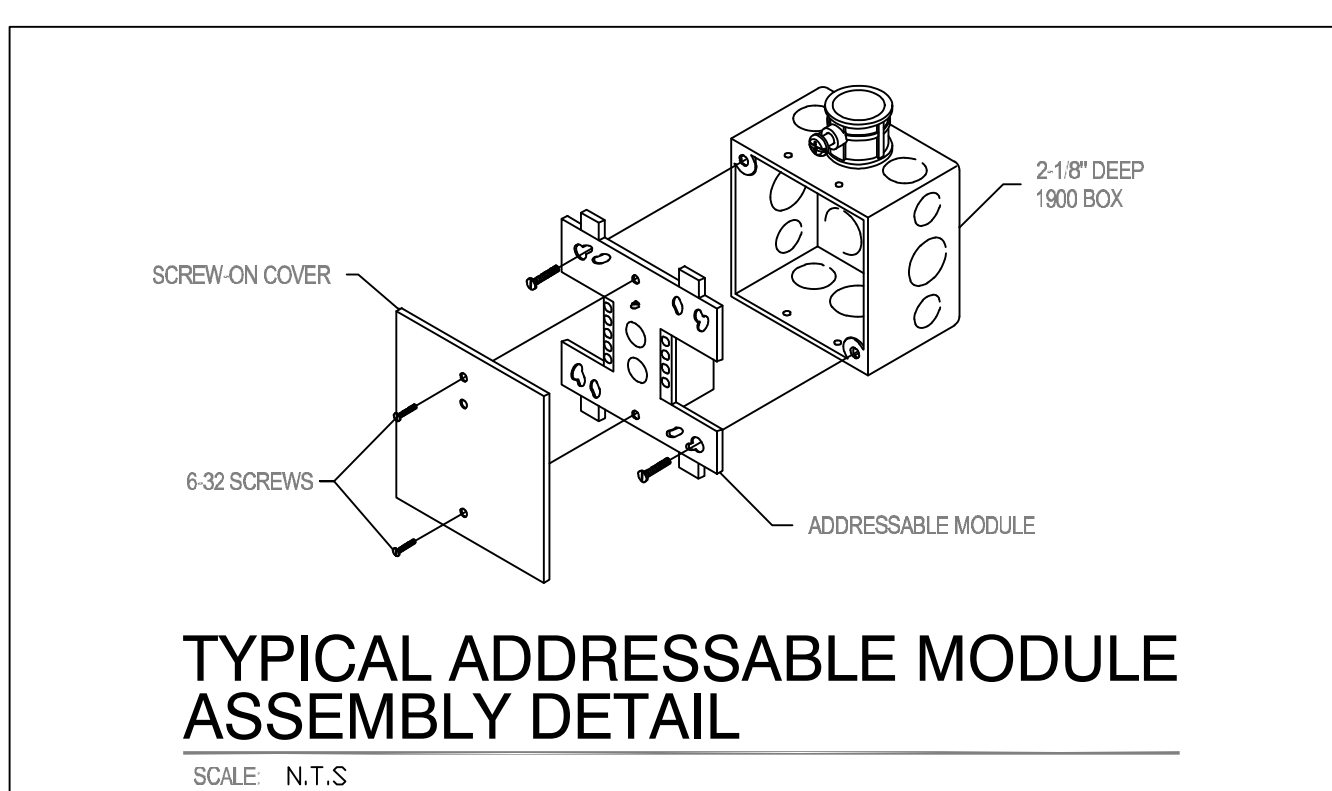
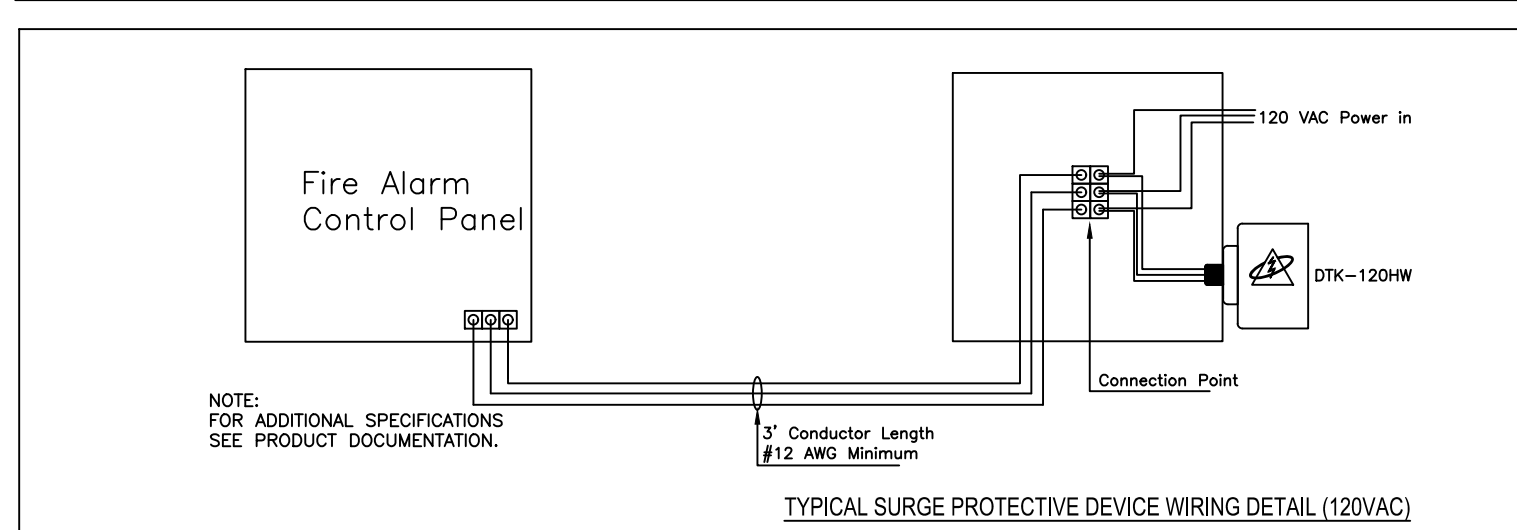
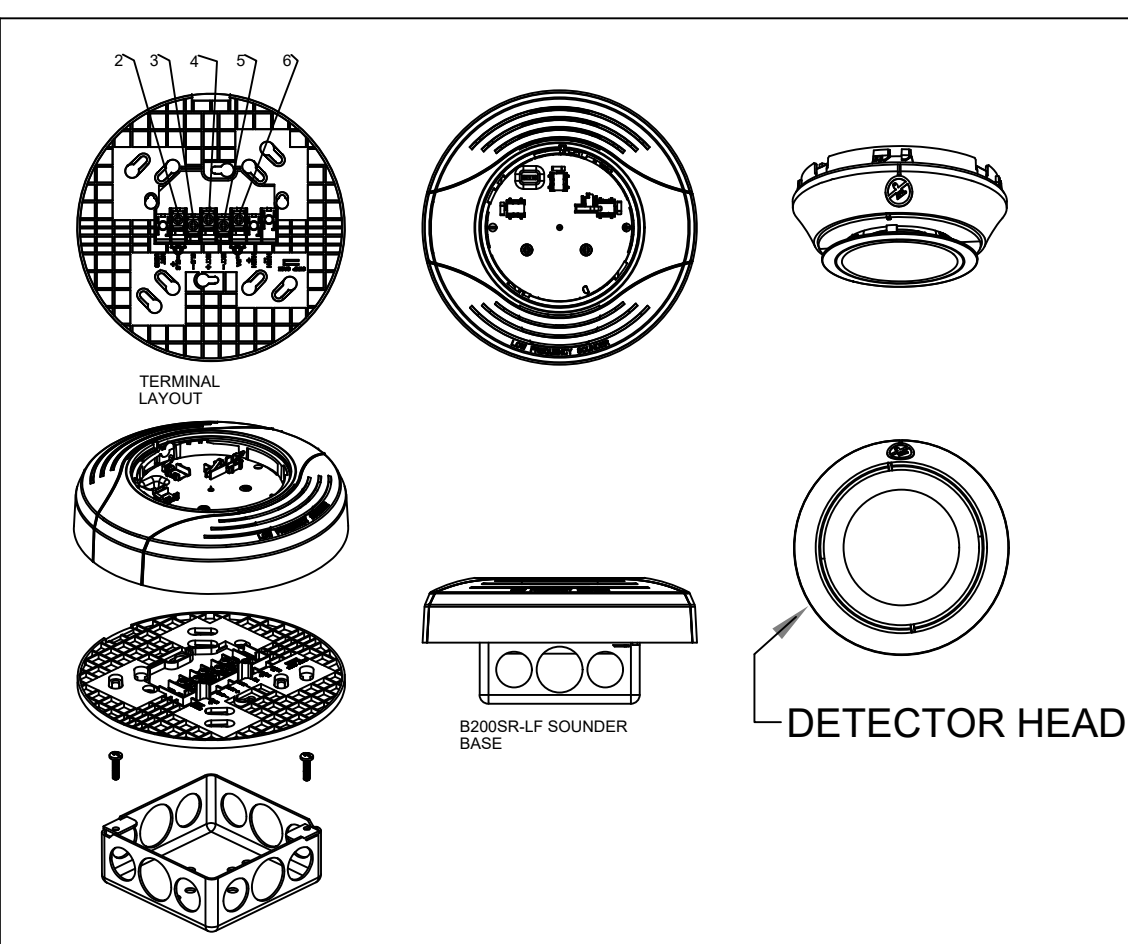
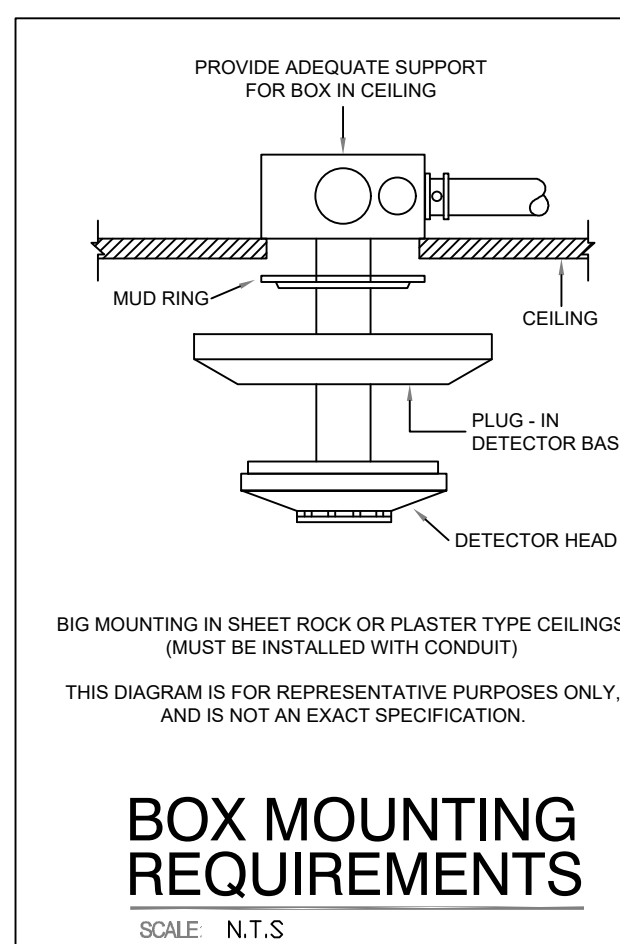
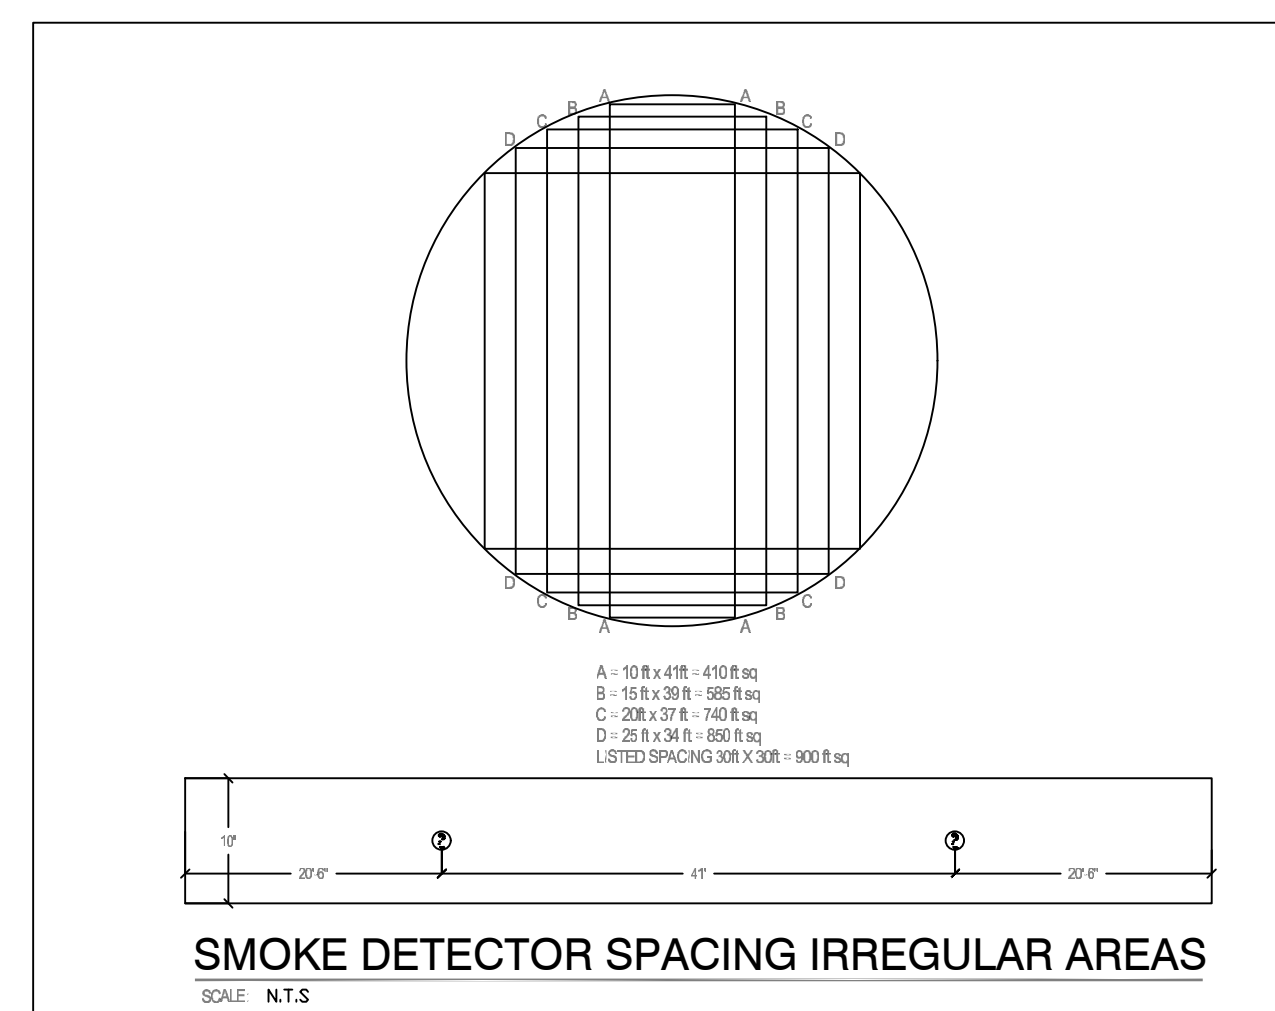
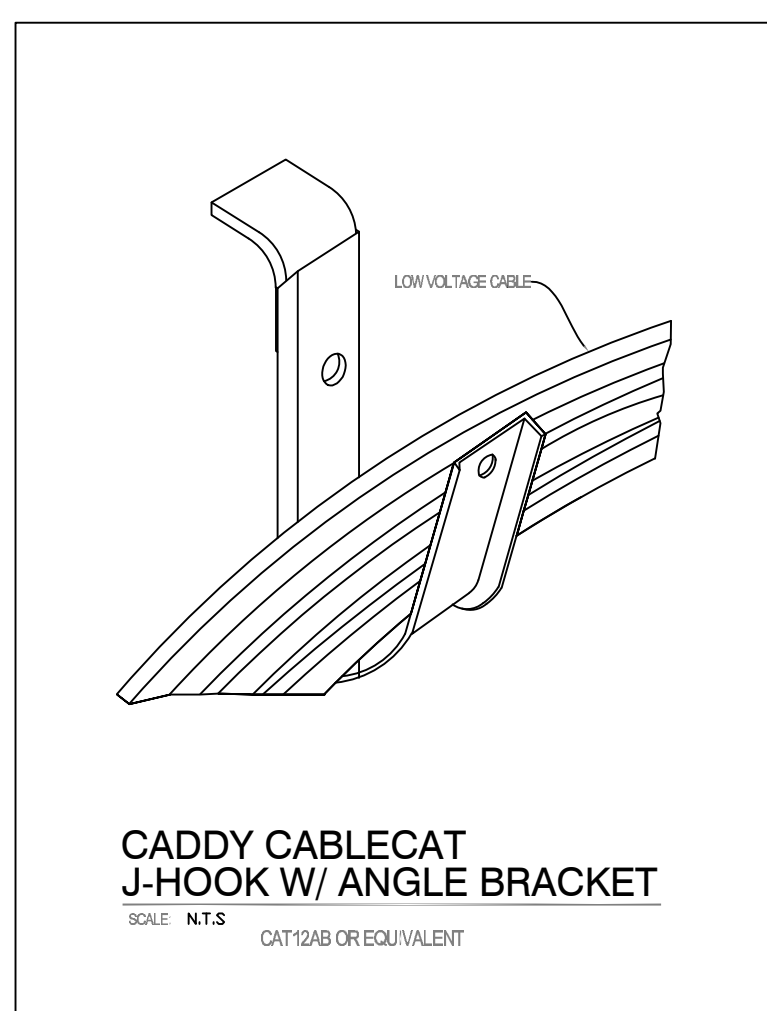
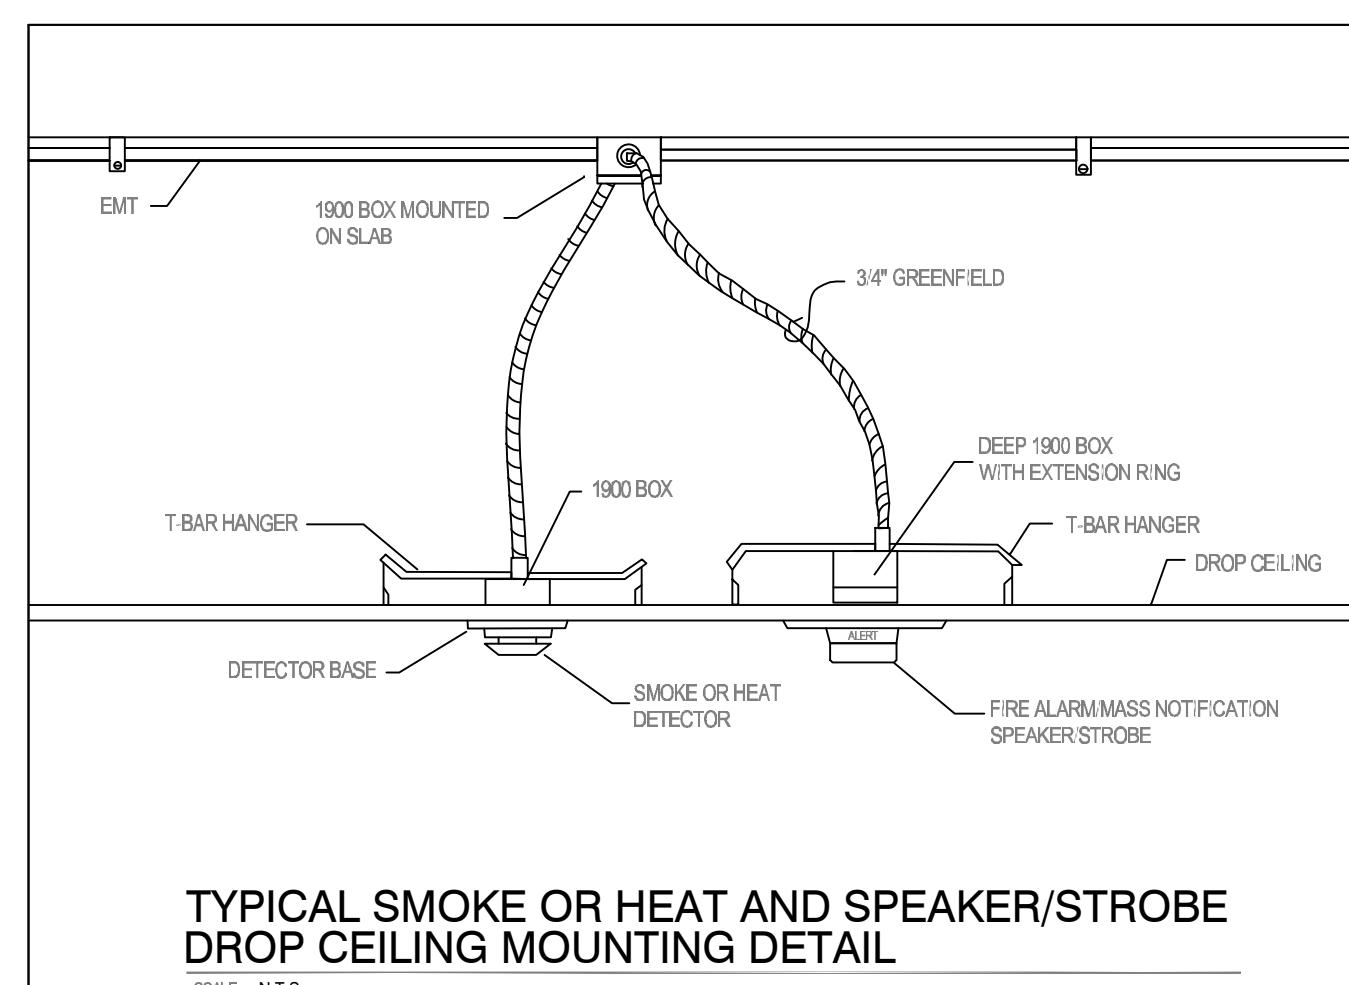


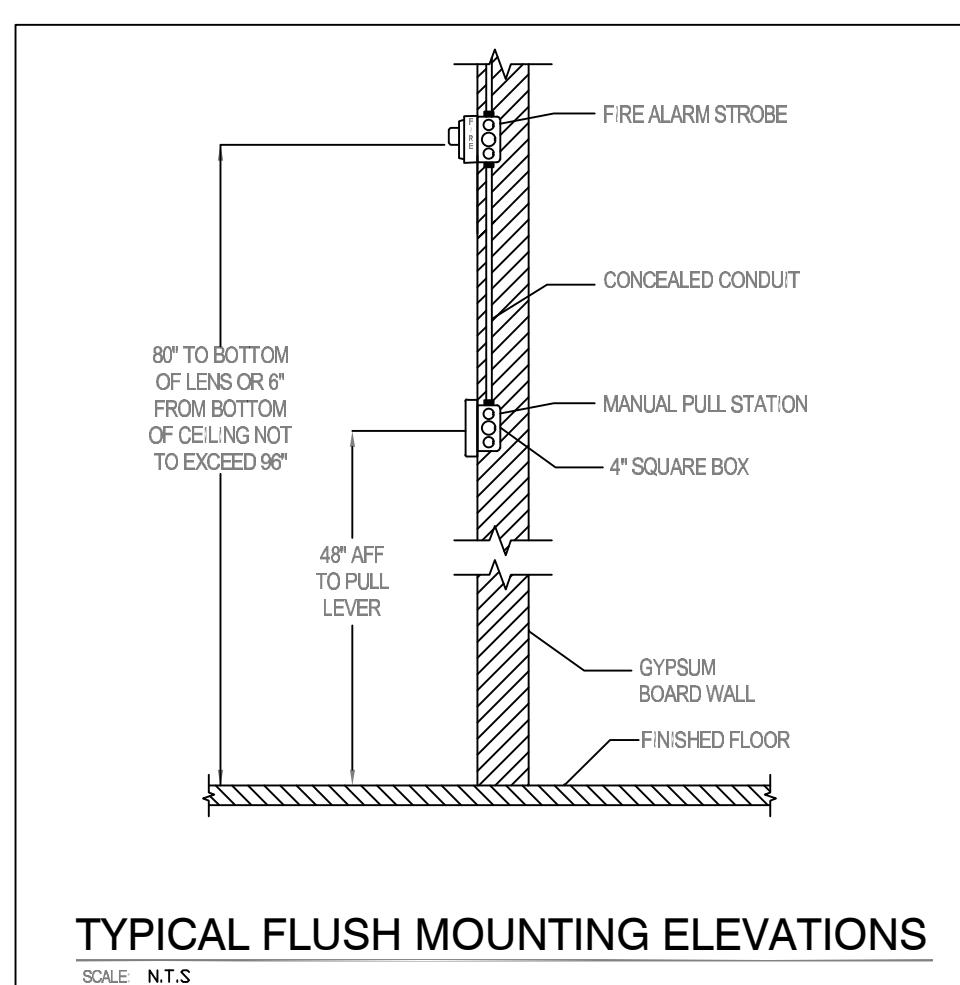

i4 Series Combination Carbon Monoxide(CO)/Photoelectric Smoke Detector COSMO-2W (2-wire) Wiring Diagram

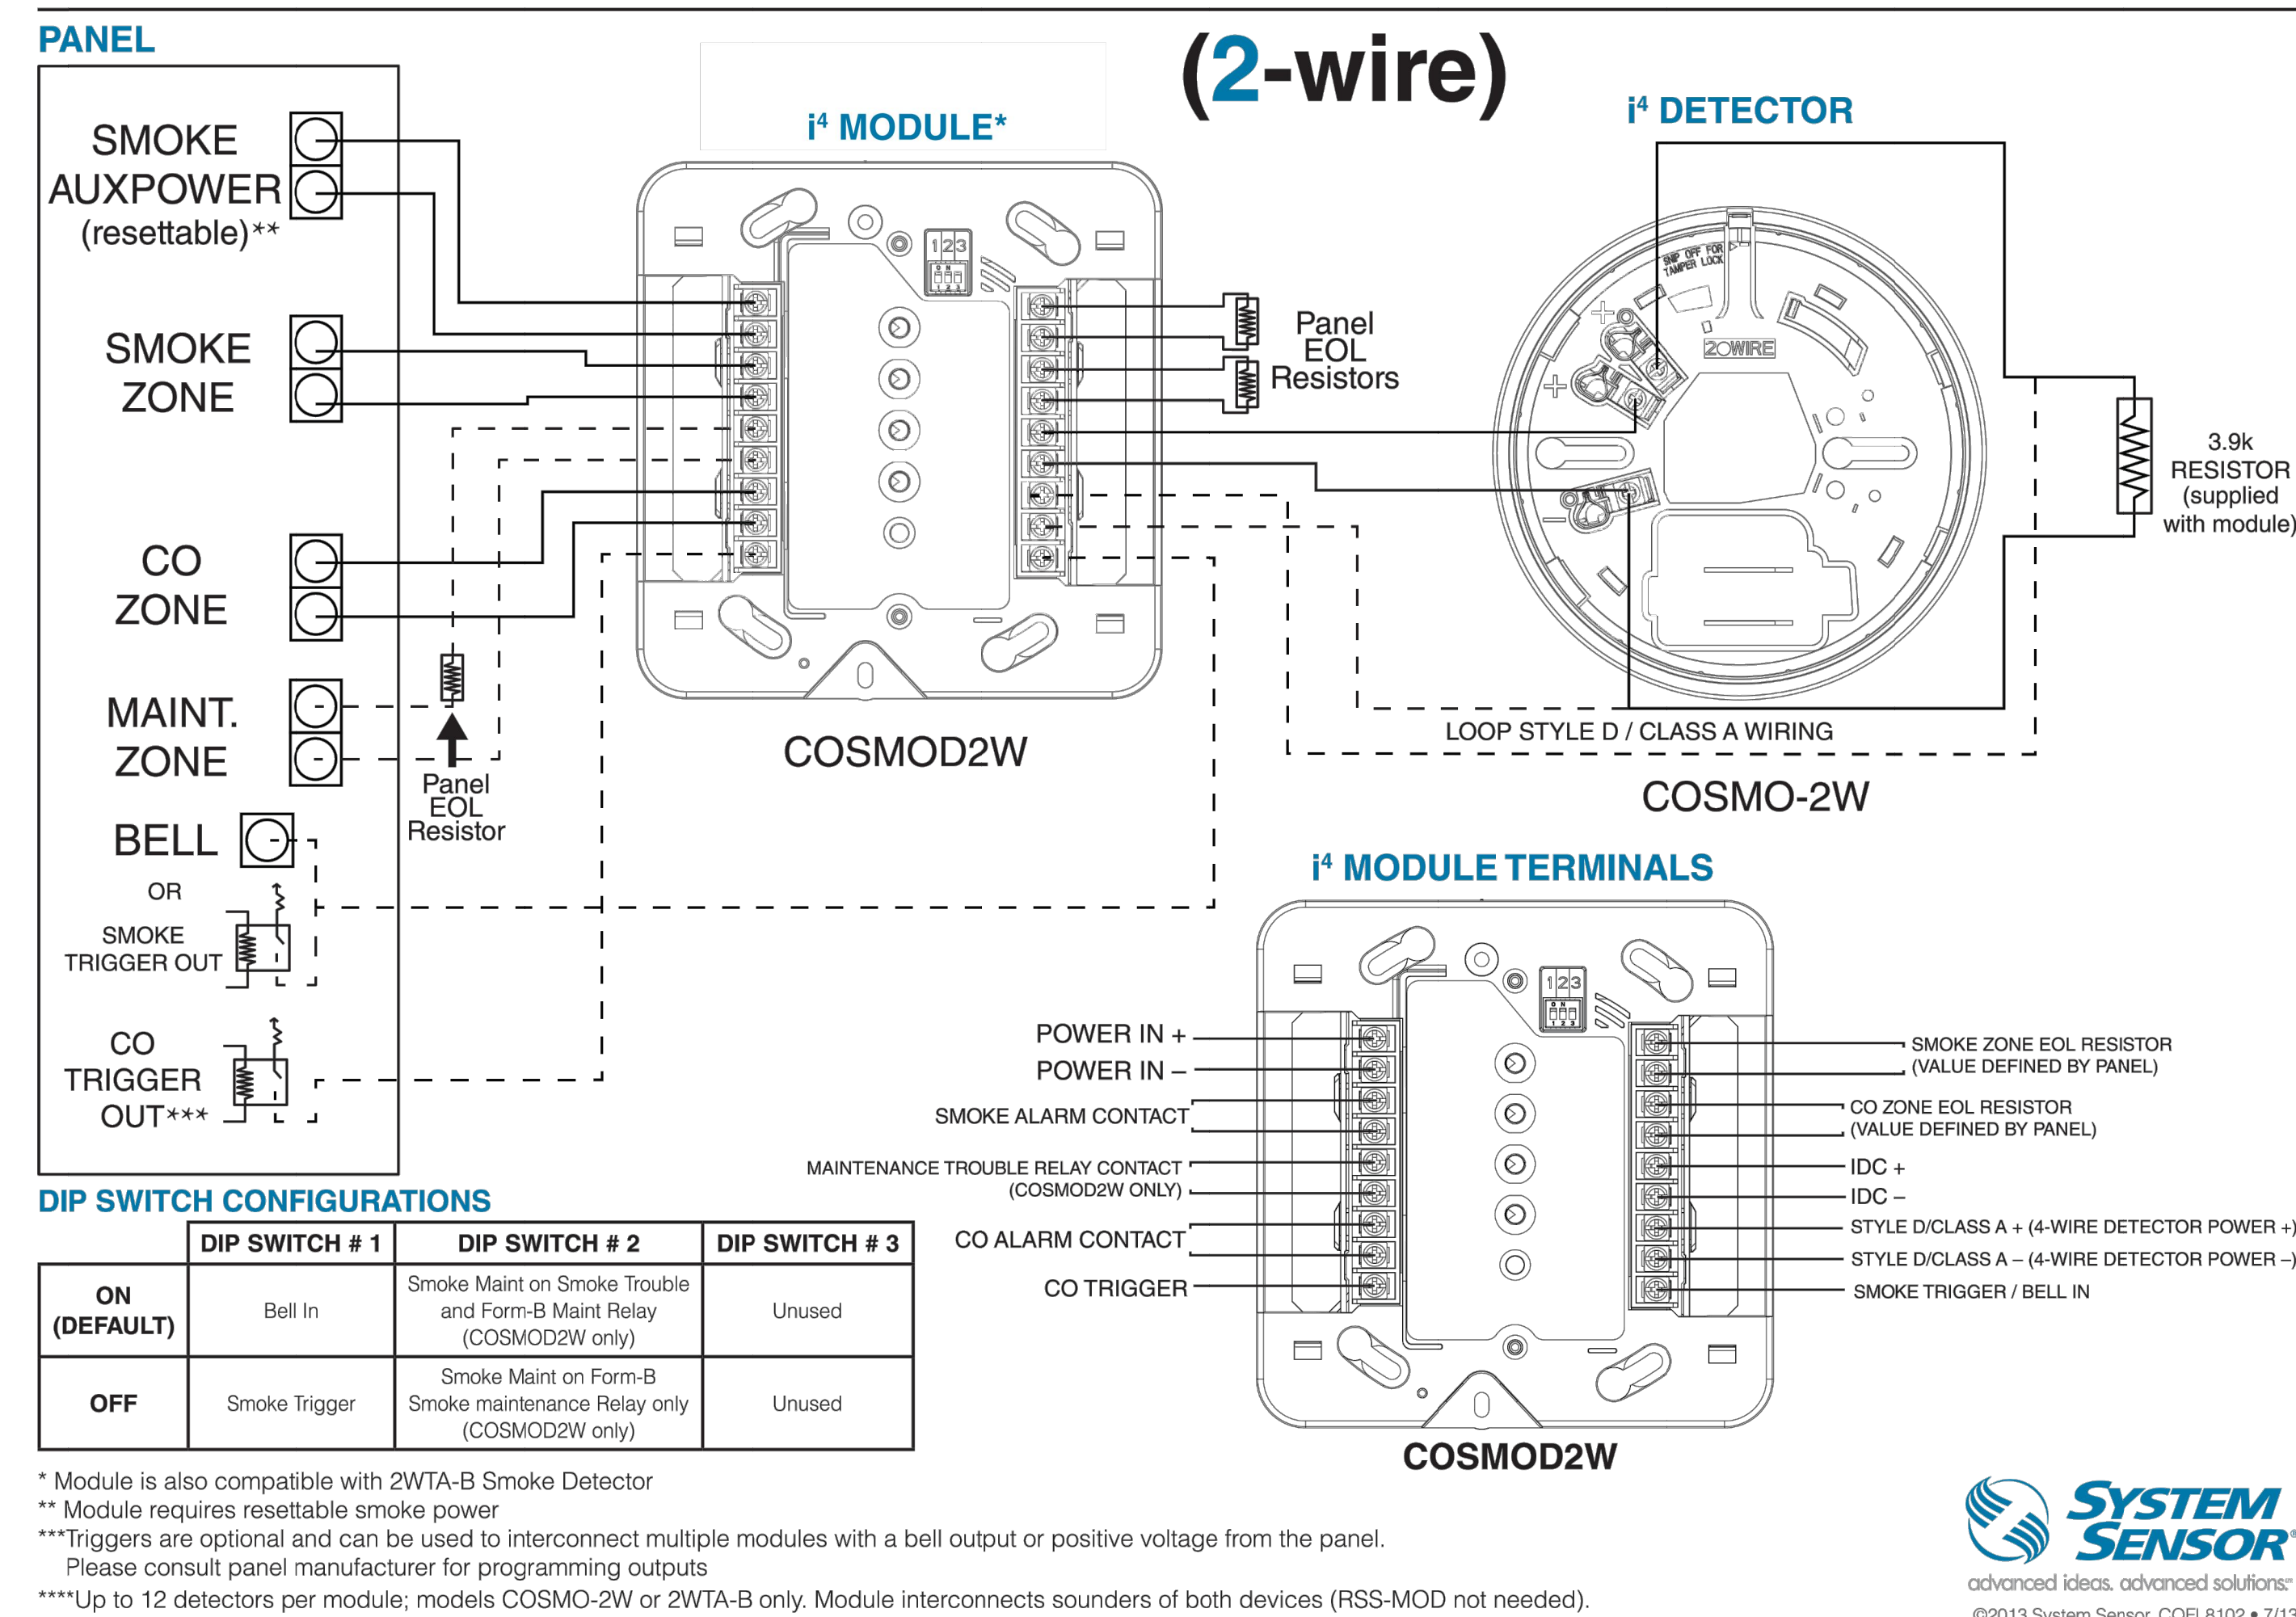

i4 Series Combination Carbon Monoxide(CO)/Photoelectric Smoke Detector COSMO-4W (4-wire) Wiring Diagram

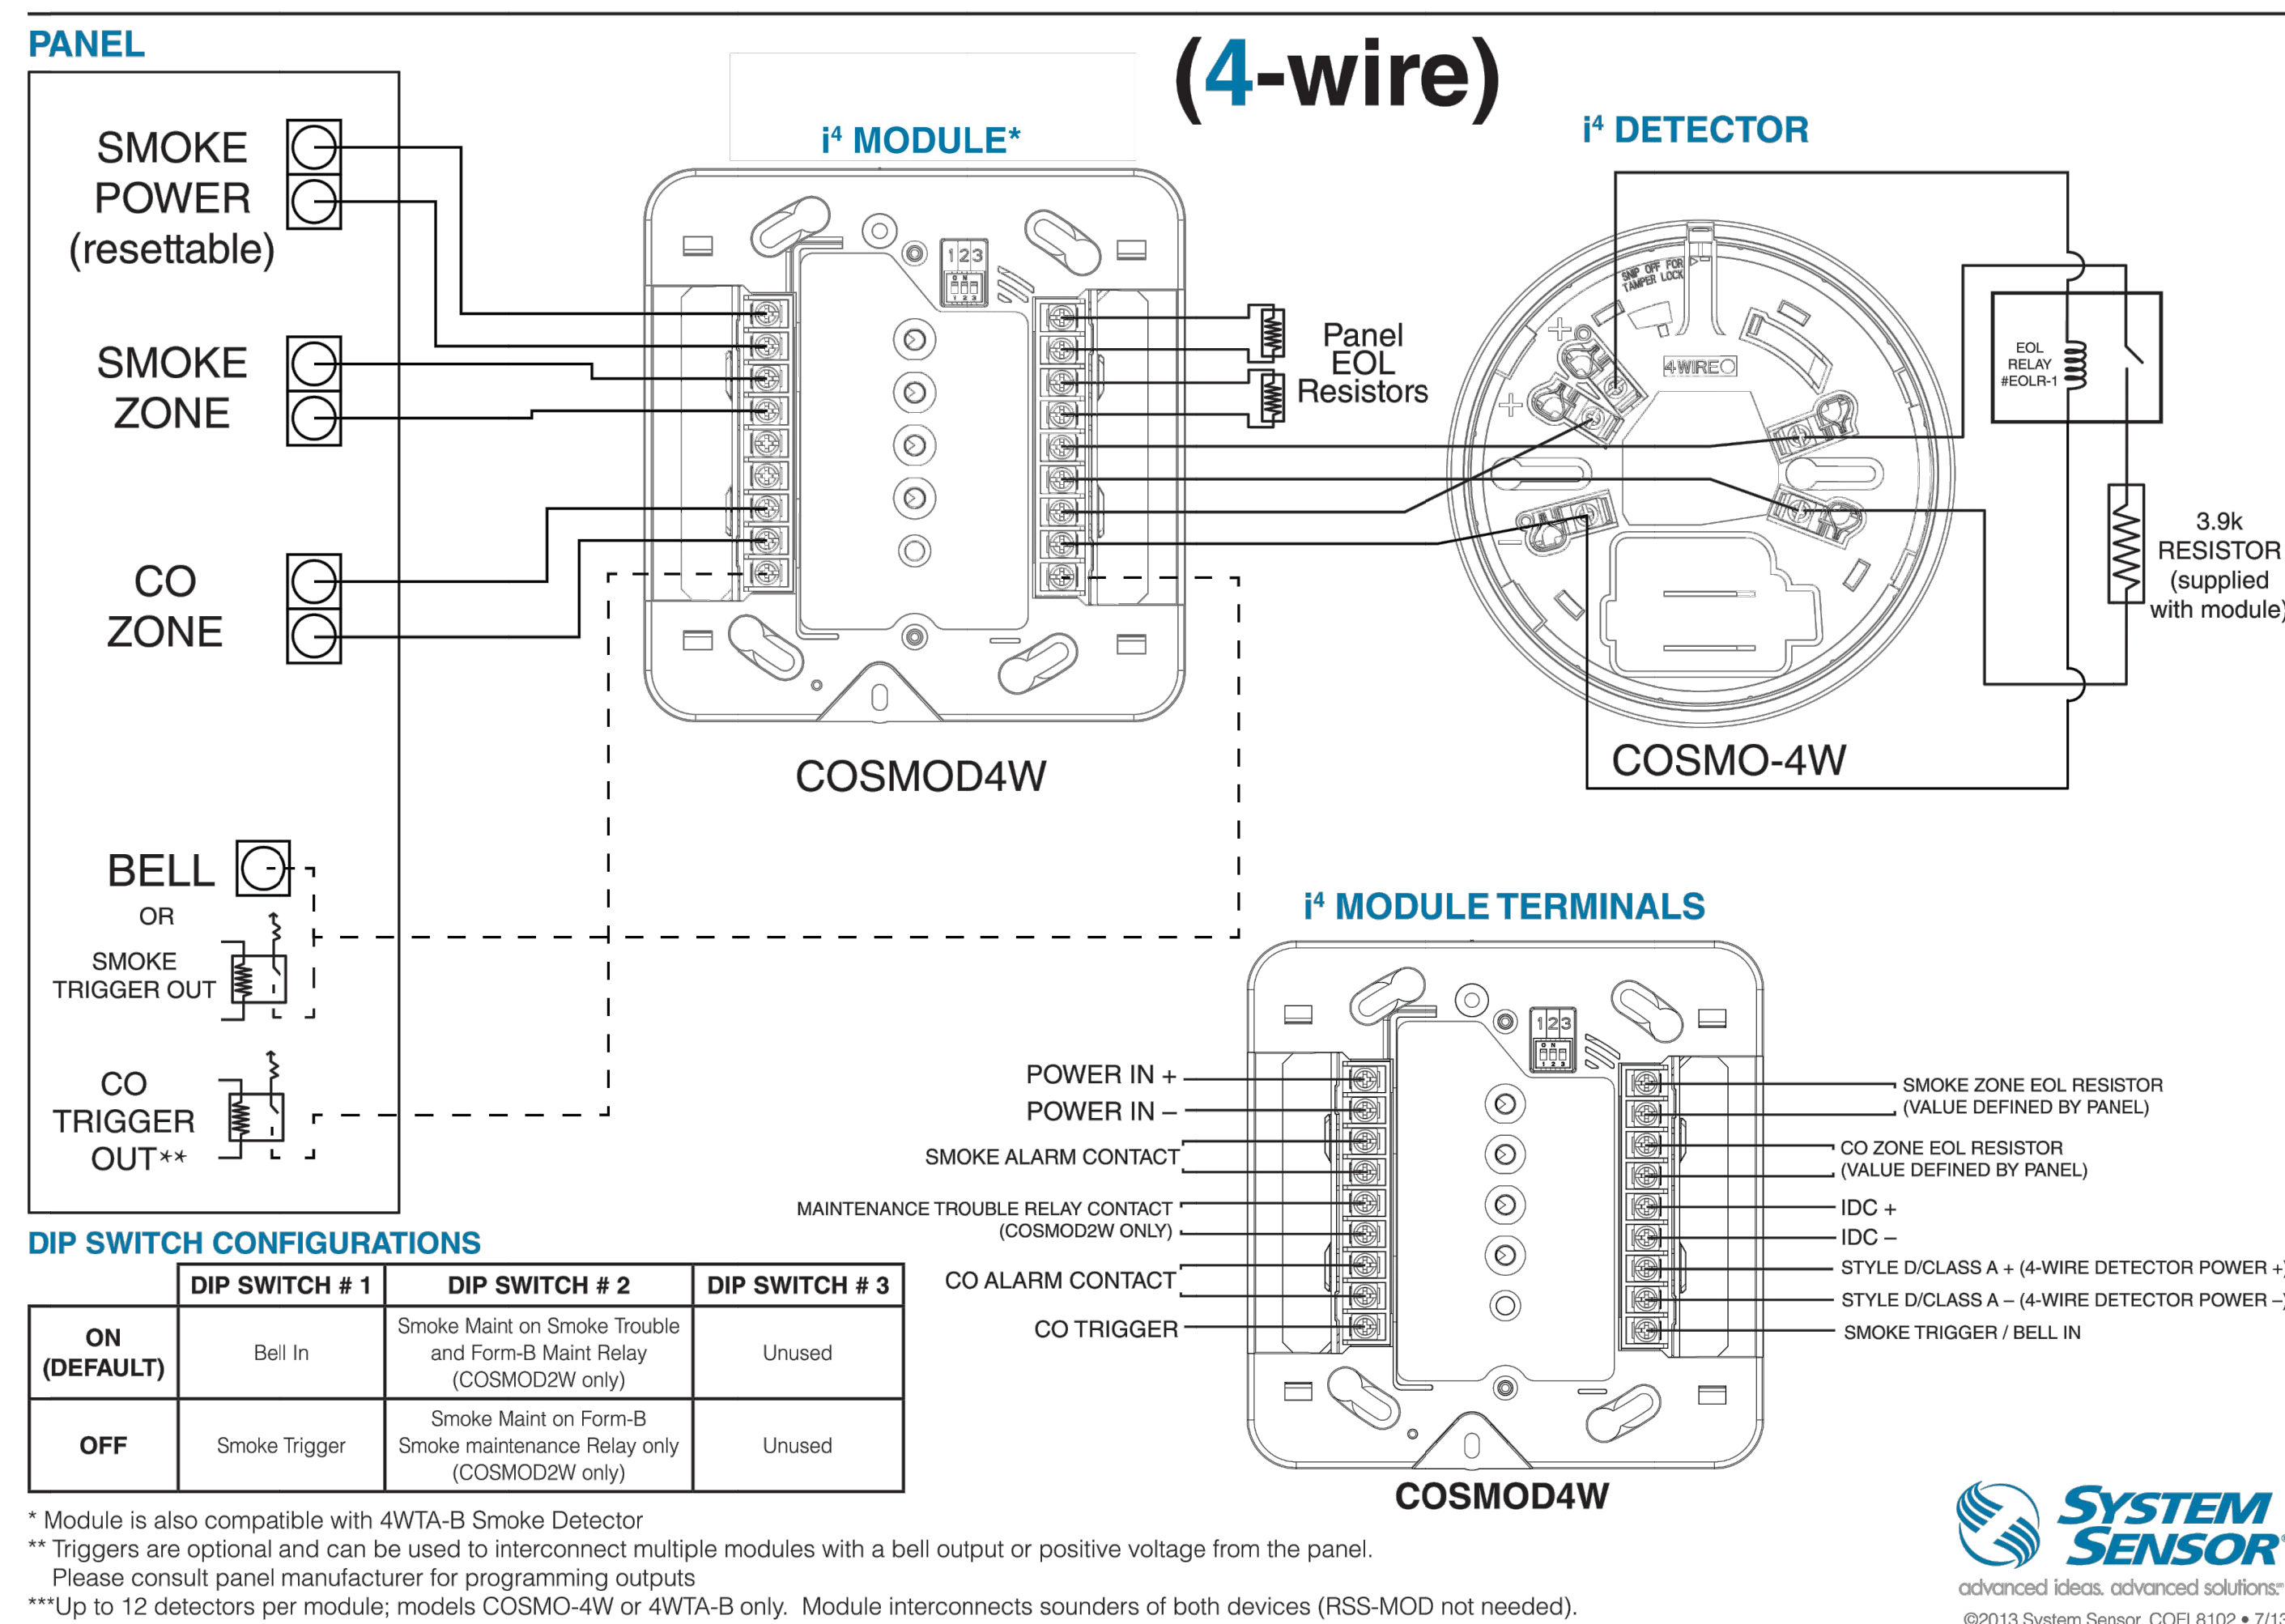

FIRE ALARM DETAILS

SCALE: NTS

This item has been digitally signed and sealed by Yanen Tomas Leyva, PE on December 19th 2025.

Printed copies of this document are not considered signed and sealed and the signature must be verified on any electronic copies.

SEAL

YENAN TOMAS LEYVA, PE
LIC. #67416
PHONE: (305) 519-1277
ADDRESS: 15873 SW 138th TERRACE
MIAMI, FLORIDA 33196

CIRCLE SECURITY SOLUTIONS, INC.
6815 SW 81st Terrace.
Miami, Florida 33143
Lic: EF0000848
PH: (305) 776-9738

NEW RESIDENTIAL SMOKE ALARM SYSTEM FOR:
CASTRO RESIDENCE
12715 Rolling Road Drive
Pinecrest, FL 33156

**FIRE ALARM
DESIGNER**
**& SECURITY SYSTEMS
DESIGN AND DRAWING**

Phone: (786)458 4234
e-mail:
generaldesigns@yahoo.com

Revisions:

ate: 12.05.2025

ADFile: 0005

project No:107

scale: AS SHOWN

FA: 4
heet 4 of 4