
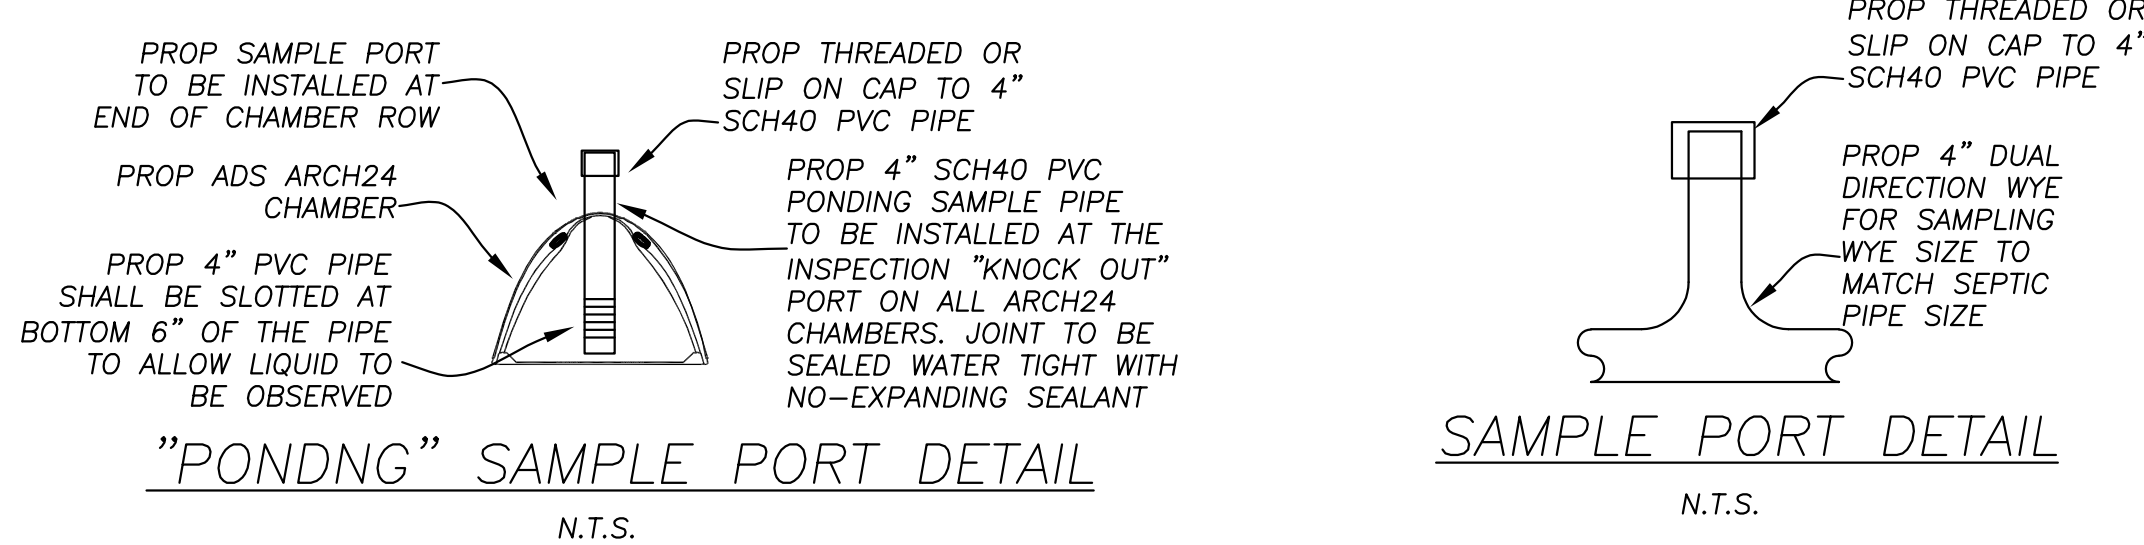
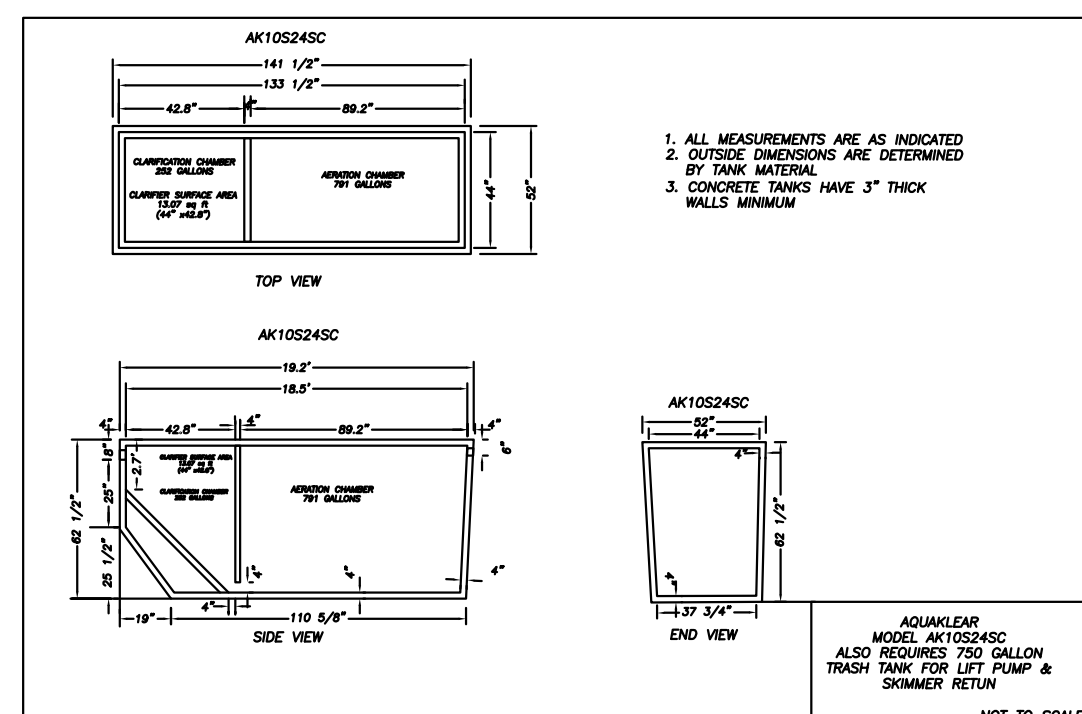
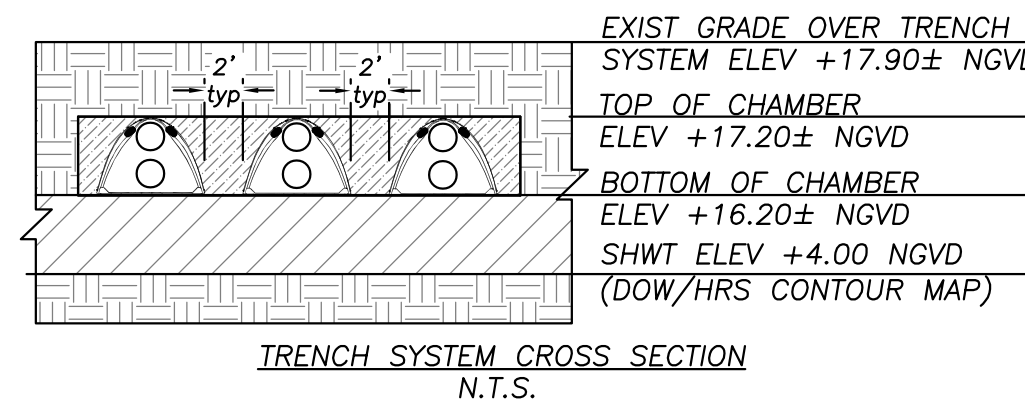


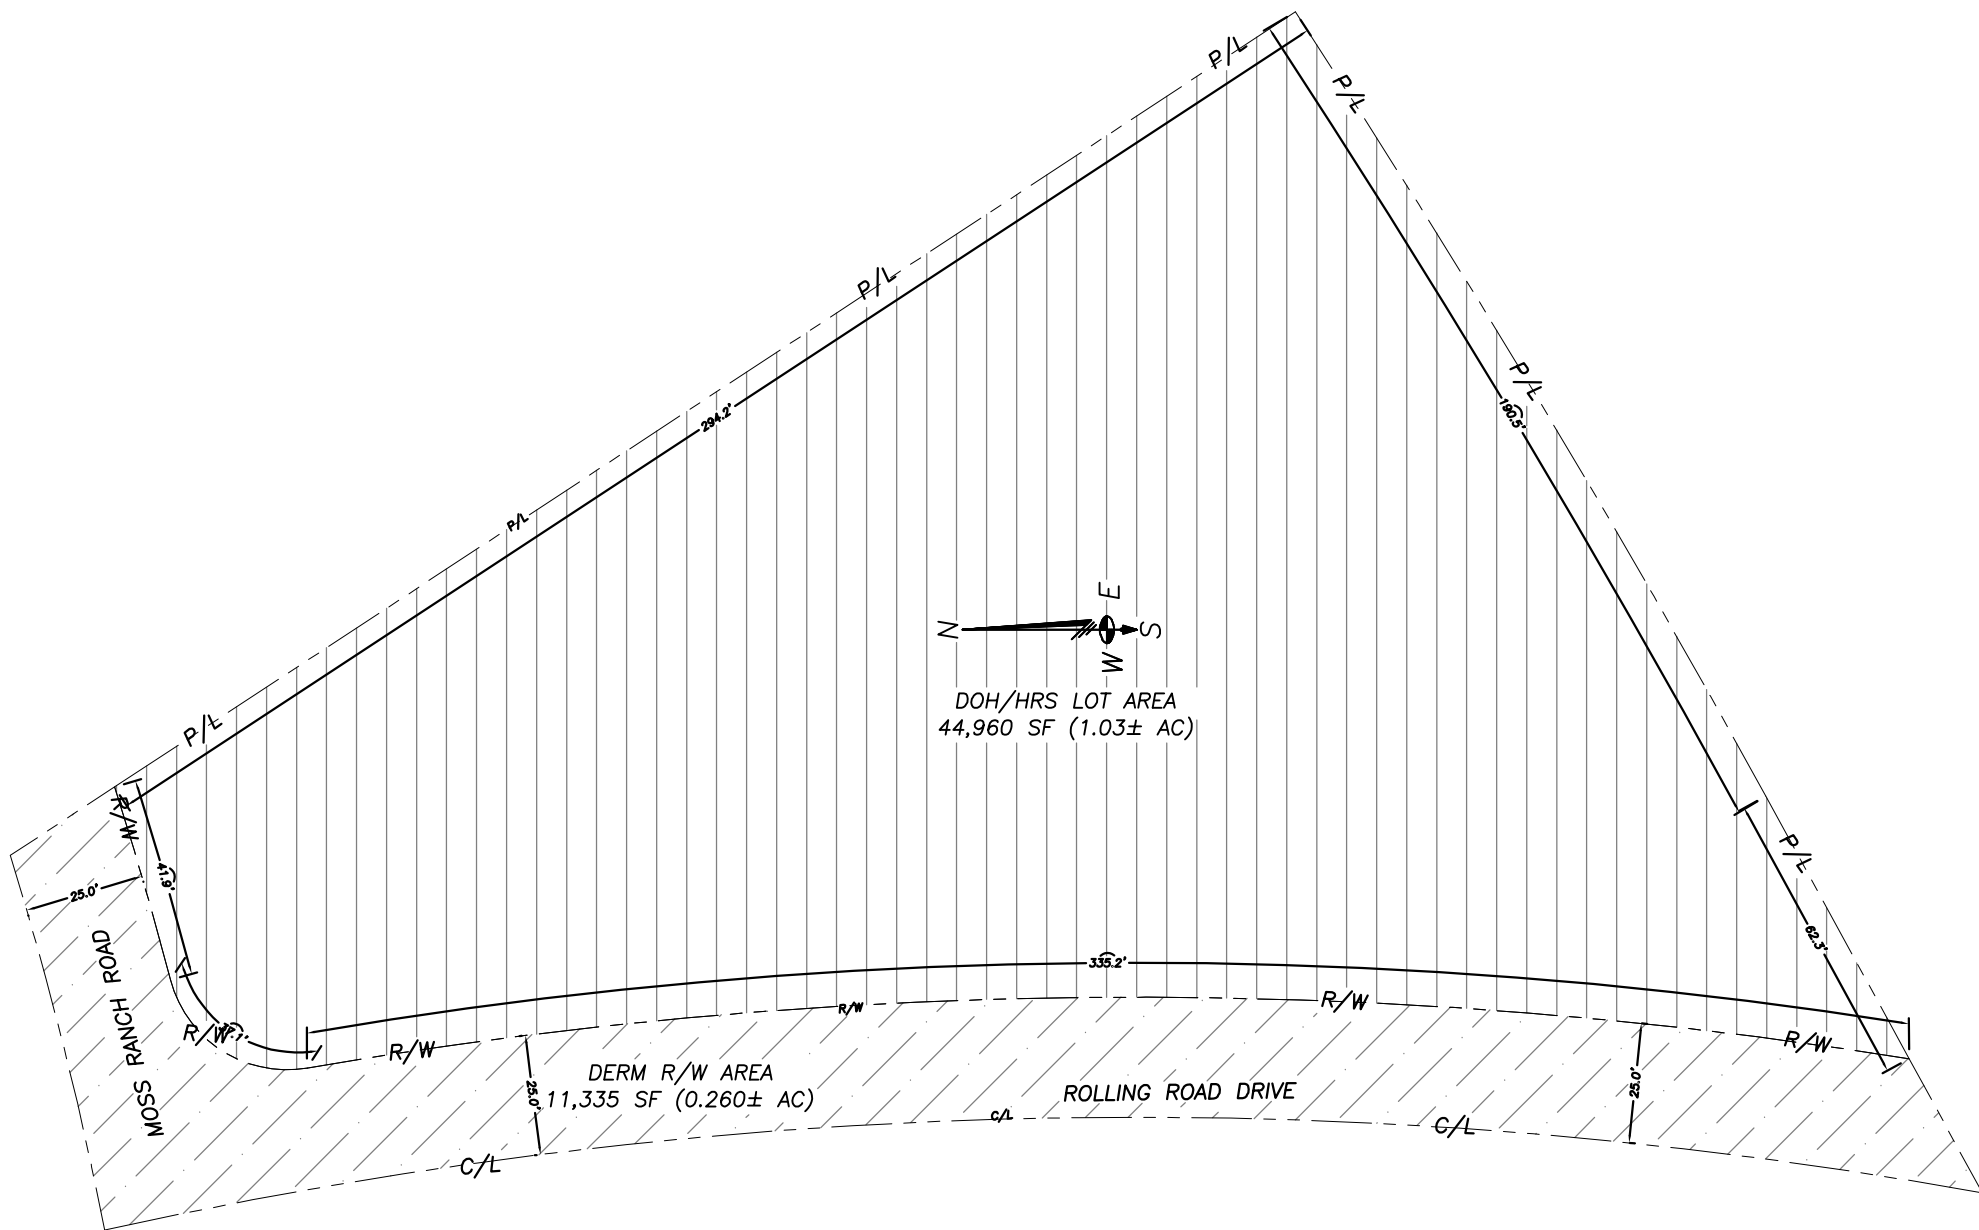

No Solid Or Heavy Vegetation Shall Be Installed On The Drain Field. No Tree Or Large Shrub Will Be Allowed Over The Drain Field Area. The Proposed On-Site Wastewater Treatment System As Shown On Site Plan Shall Not Be Closer Than 50 Feet To A Proposed Or Existing Potable-Water, 100 Feet To A Proposed Or Existing Domestic Water Main, Closer Than 10 Feet To A Proposed Or Existing Service Line, No Closer Than 10 Feet To A Public Water Main. There Shall Be No Vehicle Parked Or Driven Over The Proposed Drain Field And Drip Line Areas Shown On The Site Plan. The Proposed Landscaping Areas Shown On The Site Plan Shall Be Located In A Landscape Area Only. If Located In A Traffic The ATU Unit Shall Be In A Traffic Rated Tank. The Proposed Pump Tank Shown On The Site Plan Shall Be Located In A Landscape Area Only. If Located In A Traffic Area The Pump Tank Shall Be Traffic Rated Tank.

CAROL CASTRO RESIDENCE
WATER AND SEWER FACILITIES
SEPTIC PLAN, NOTES & DETAILS
12715 ROLLING ROAD DRIVE
MIAMI, FLORIDA

REVISIONS

THIS ITEM HAS BEEN DIGITALLY
SIGNED AND SEALED BY
KEN N. GROCE P.E. ON THE DATE
ADJUDICATED TO THE SEAL

For The Firm By:
KEN W. GROCE, P.E.
FL. Reg. No. 35944
Civil Engineer

Scale: As Shown In Views
Designed By: KWG

Drawn By:	CDS
Checked By:	KWG
Date:	5.2.2023

Project No: 23-26

Sheet:

WS-1 1 OF 1