



PLUMBING SITE PLAN

12715 ROLLING ROAD DRIVE
PINECREST, FL 33156

SEAL

PREPARED BY: \$

CHECKED BY: NAR

REV	DATE	DESCRIPTION
0	12/5/25	ISSUED BLDG DEPT
2	04/2/24	OWNER C
4	12/05/25	COORDIN

SCALE: AS SHOWN

JOB NO.: 22-PRO-

SHEET NO.

PS-1

E

LOCATION MAP
(NOT TO SCALE)

EXIST DOMESTIC WELL
12555 MOSS RANCH ROAD
FOLIO #20-5013-003-0190
III'± FROM SEPTIC SYSTEM

ALL OTHER ADJACENT LOTS ARE
CONNECTED TO PUBLIC WATER

PROPOSED PLUMBING SITE PLAN

SCALE: $3/32" = 1'-0"$

PROPOSED 1000 GALLONS UNDERGROUND
PROPANE TANK. 10' DISTANCE BETWEEN TANK AND
FROM ANY STRUCTURE AND PROPERTY LINE.
COORDINATE WITH GAS COMPANY. LOCATION AND
INSTALLATION SHALL COMPLY WITH NFPA 58.

JOB # 22-1001

Amarilis Rodriguez, P.E.
License Number 60236
C.A. 26358

Signature _____

Date _____





2020 Ponce de Leon, Suite 100
Coral Gables, Florida 33134
Phone > 305 444 9809
Fax > 305 444 9827

Engineering Design
 > Mechanical > Elec
 > Plumbing > Fire
www.arpe-en

Signature _____

Date _____

PAPER SIZE: ARCH EXPAND E1 (30" X 42")

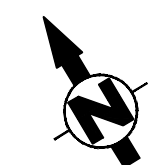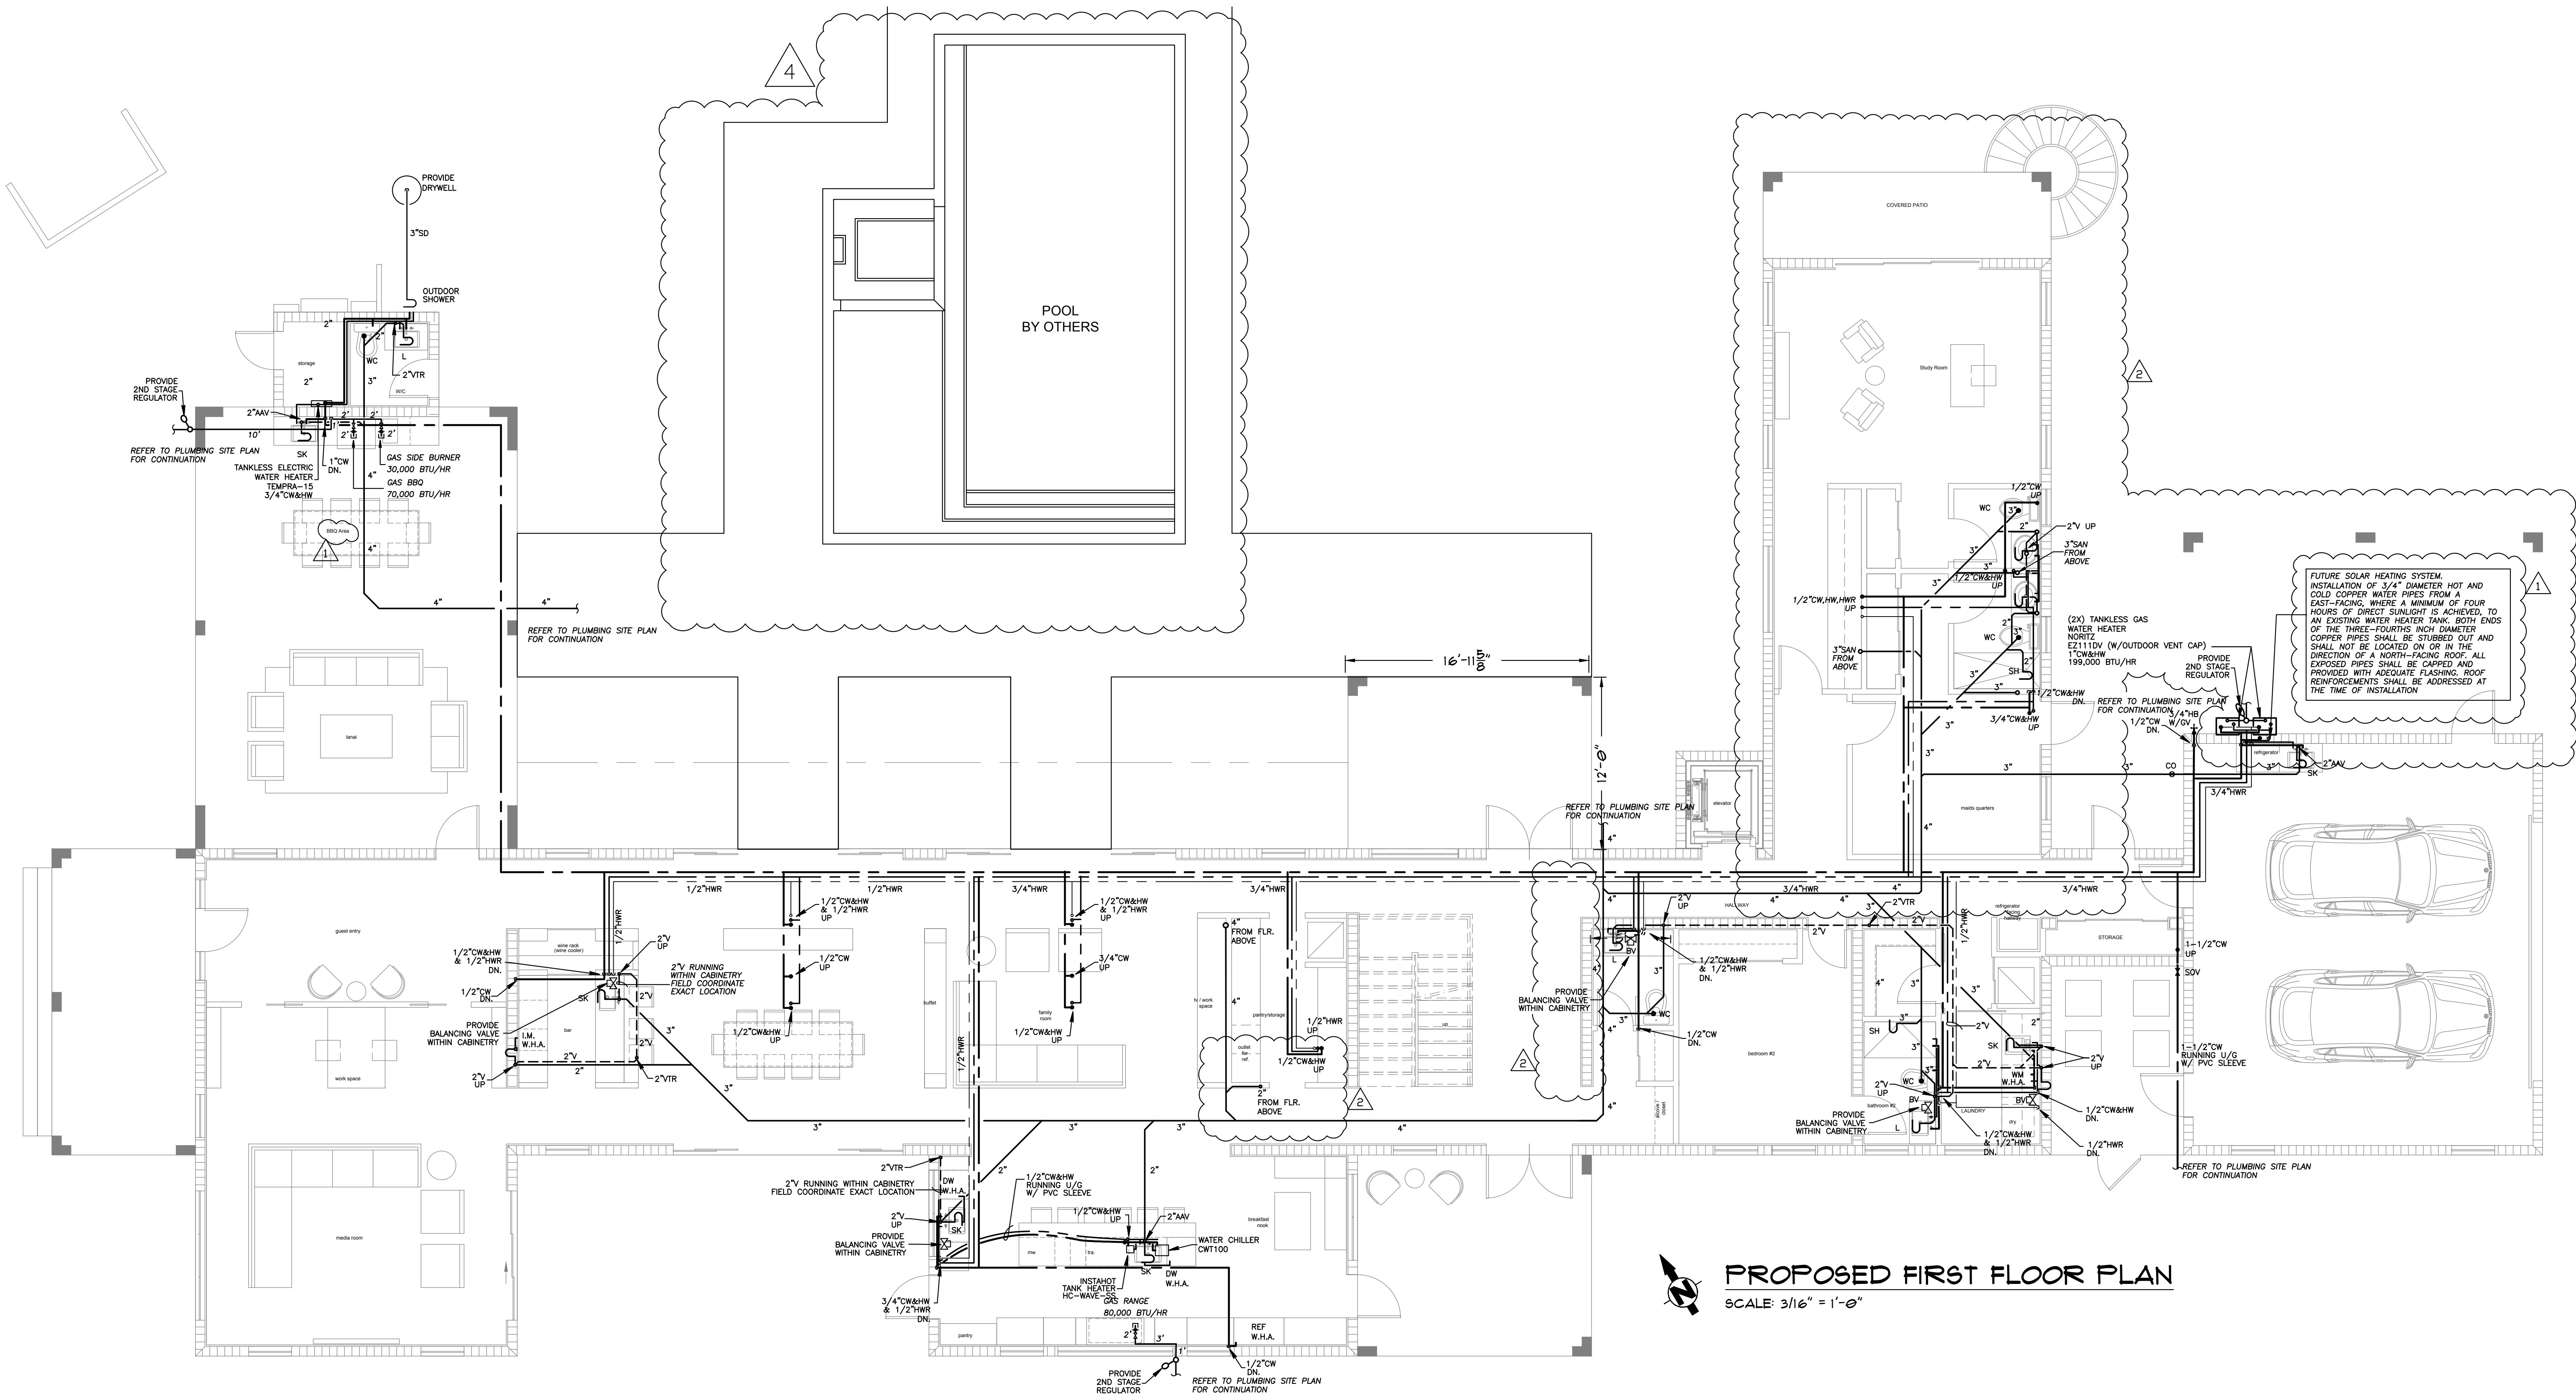

PROPOSED FIRST FLOOR PLAN
SCALE: 3/16" = 1'-0"

SEAL

PREPARED BY: **BY**

CHECKED BY: **NAC**

REV	DATE	DESCRIPTION
0	07/09	ISSUED FOR BLDG DEPT REVIEW
1	08/07/11	CITY COMMENTS
2	08/07/11	OWNER CHANGES
4	03/01/12	COORDINATION

SCALE: **AS SHOWN**

JOB NO.: **22-PRO-0020**

SHEET NO.	REV
P-1	0

2020 Ponce de Leon, Suite 1002
Coral Gables, Florida 33134
Phone > 305 444 9809
Fax > 305 444 9827

Engineering Design:
> Mechanical > Electrical
> Plumbing > Fire Protection
www.arpe-eng.com

Signature _____
Date _____

JOB # **22-1008**
Amarilis Rodriguez, P.E.
License Number 60236
CA 2039