

SEAL

PREPARED BY: SY

CHECKED BY: NAC

REV.	DATE	DESCRIPTION
1	12/19/20	ISSUED FOR ELEC. DEPT. REVIEW
2	01/26/2021	DRY COMMENTS
3	01/27/21	OWNER CHANGES
4	01/26/2020	COORDINATION

SCALE: AS SHOWN


JOB NO.: 22-PRO-0028

SHEET NO. E-1

REV

JOB # 22-1008

Amarilis Rodriguez, P.E.
License Number 60236
C.A. 2019

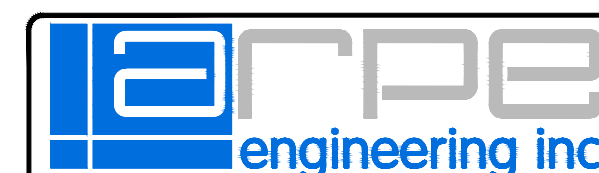


2020 Ponce de Leon, Suite 1002
Coral Gables, Florida 33134
Phone > 305.444.9809
Fax > 305.444.9827

Engineering Design
> Mechanical > Electrical
> Plumbing > Fire Protection
www.arpe-eng.com

Signature
Date

PAPER SIZE: ARCH EXPAND E1 (30" X 42")

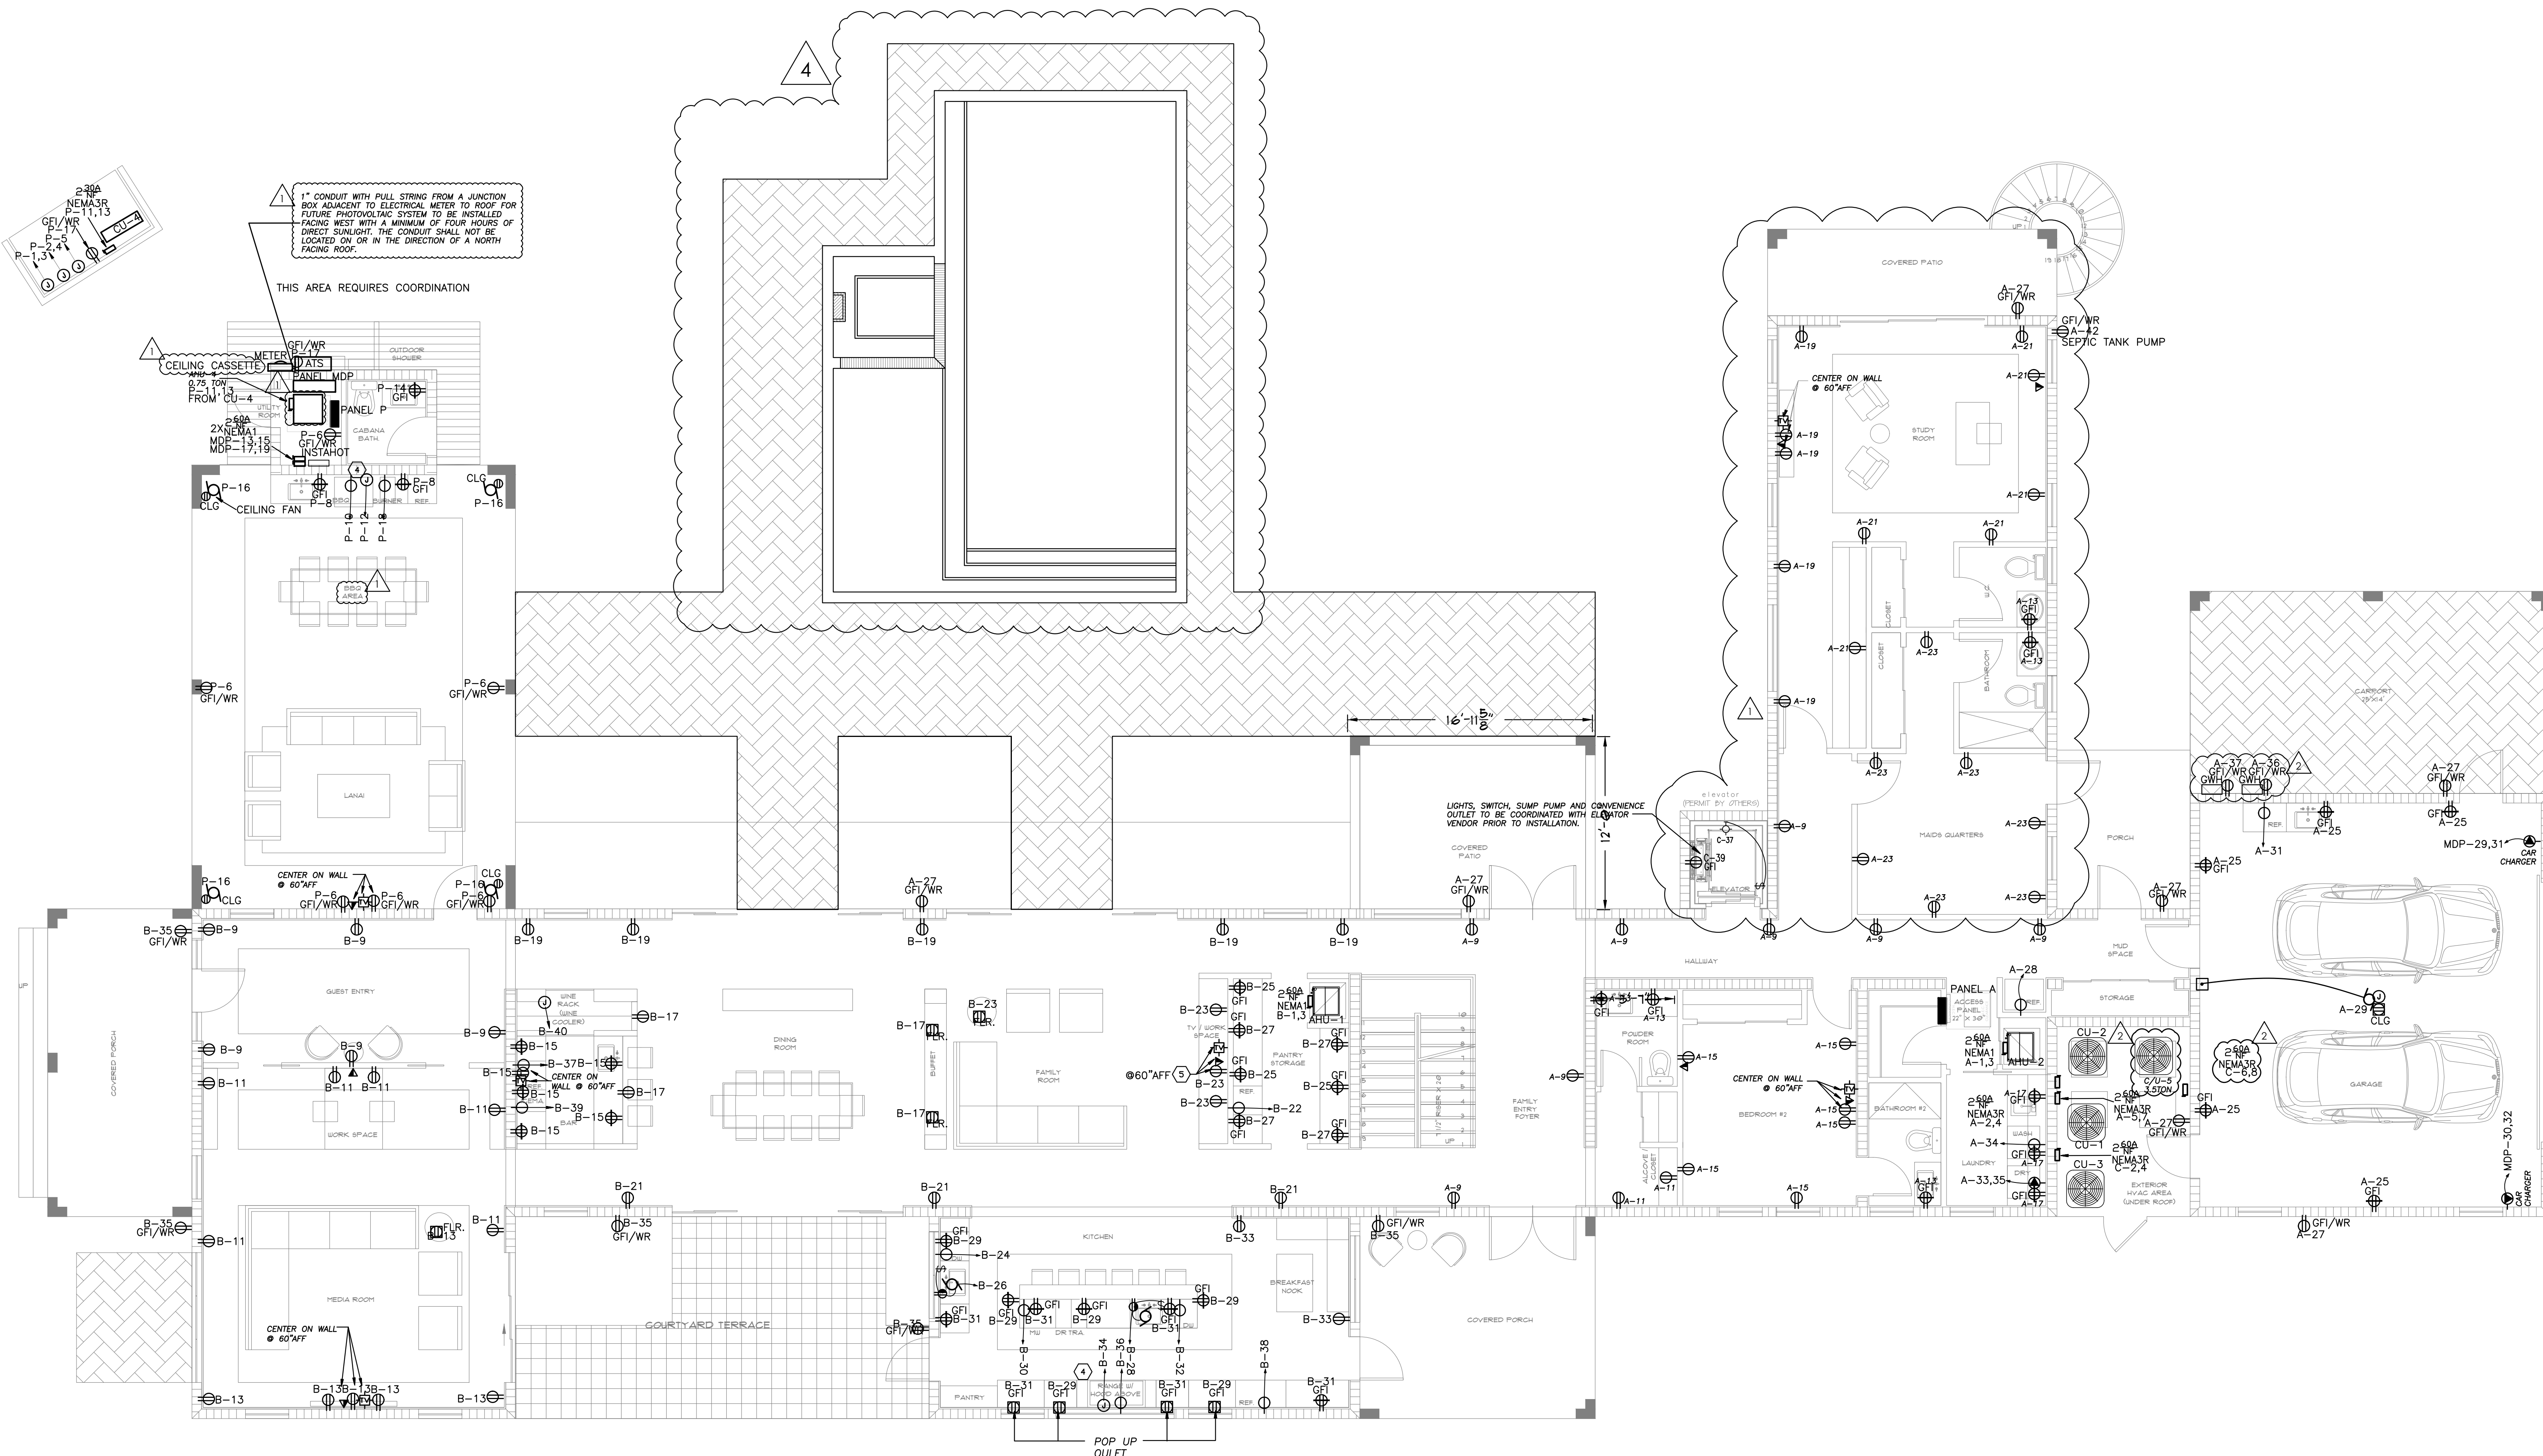

POWER FIRST FLOOR PLAN
SCALE: 3/16" = 1'-0"