

04


04

04


03

04

03

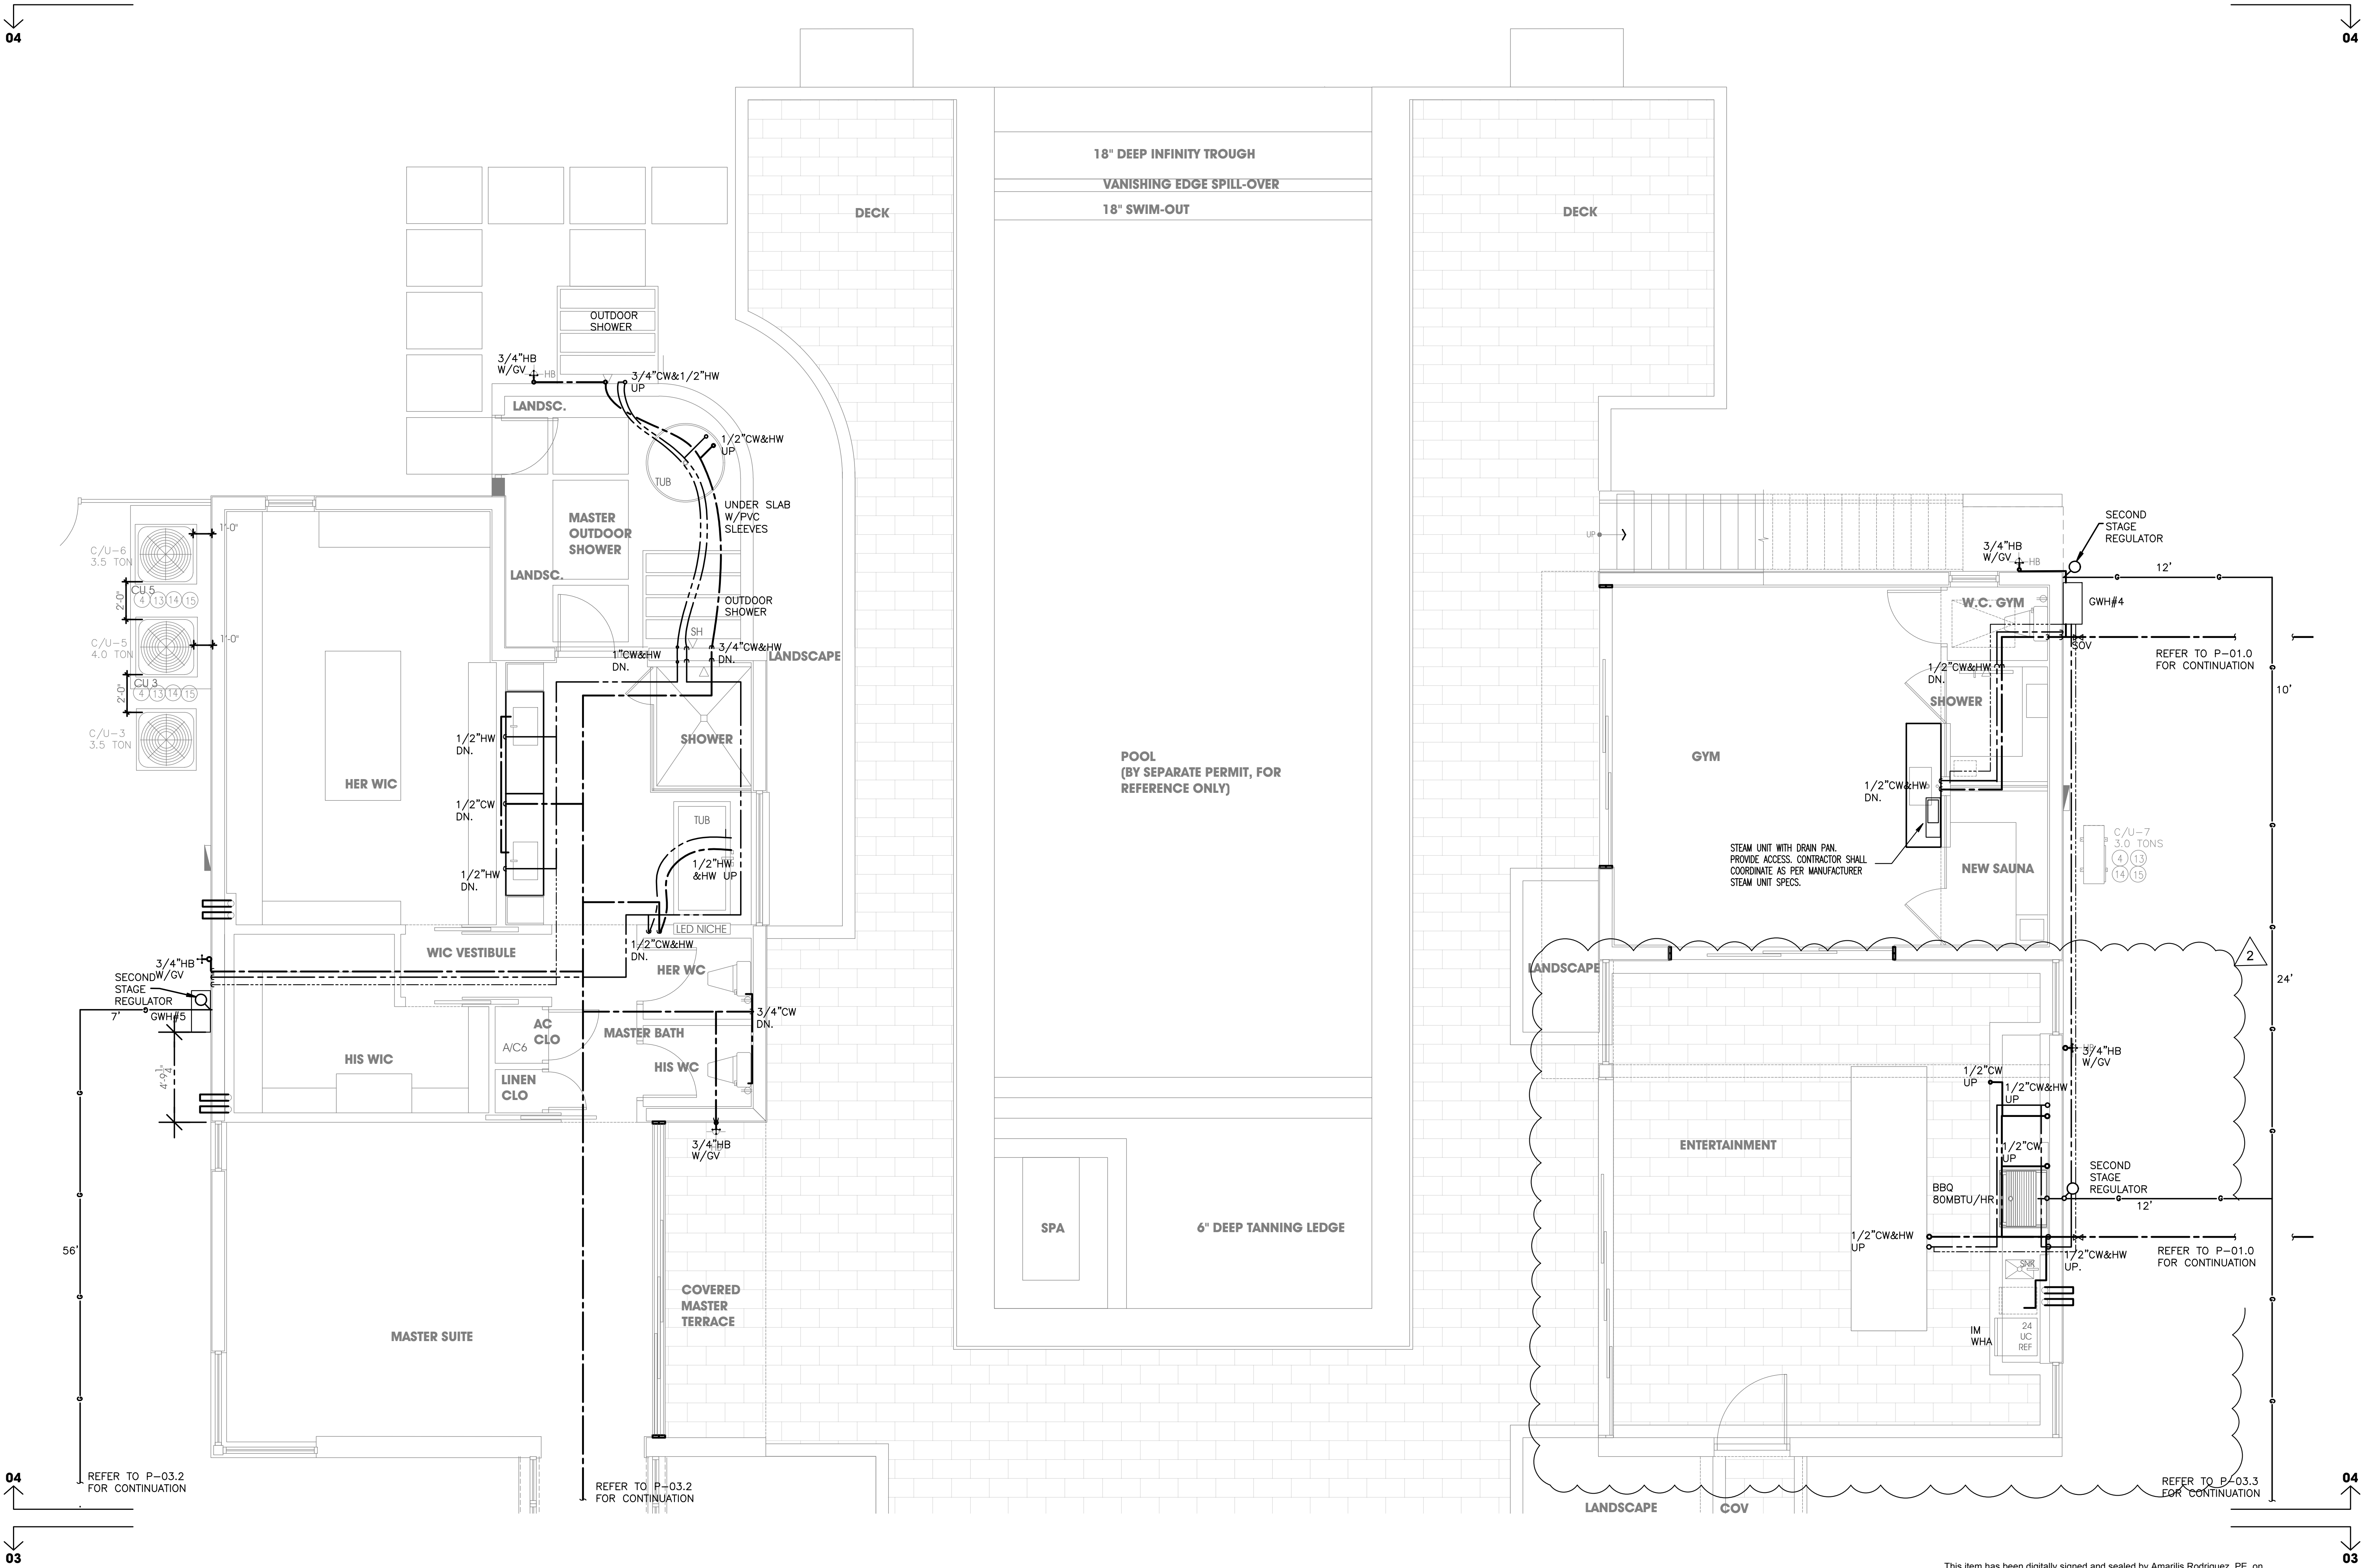

WATER & GAS PARTIAL FIRST FLOOR PLAN: 04
SCALE: 1/4" = 1'-0"

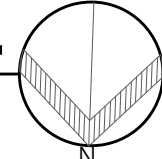

This item has been digitally signed and sealed by Amarilis Rodriguez, P.E. on
Printed copies of this document are not considered signed and
sealed and the signature must be verified on any electronic copies. JOB# 24-0407




2020 Ponce de Leon Blvd., Suite 1002
Coral Gables, Florida 33134
Phone > 305 444 8809
Fax > 305 444 9827

Amarilis Rodriguez, P.E.
License Number 60236
C.A. 26359

Engineering Design:
> Mechanical > Electrical
> Plumbing > Fire Protection
www.arpe-eng.com

Signature _____
Date _____

NOTES

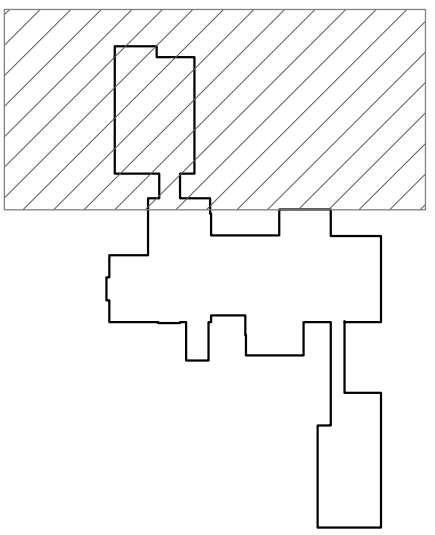

KEY PLAN
SCALE: 1/4" = 1'-0"

LOCUS ARCHITECTURE INCORPORATED
500 South Dixie Highway, Suite 307
Coral Gables, Florida 33146
Tel: (305) 740-0120
Email: locus@locusarchitecture.net
License AR 13937

CONSULTANT(S)

NO.	REVISION/SUBMISSION	DATE
	OWNER REVIEW	03-11-24
	PERMIT SUBMITTAL	06-07-24
2	OWNER CHANGES	03-30-26

PROJECT

New 2-Story Residence:
6100 W Suburban Dr, Pinecrest, FL
33156

DRAWING

Partial First Floor Plan: 04

SEAL	SCALE As Shown
	DRAWN
	REVIEWED
Nelson de Leon AR 13937	PROJ. NO. 351

SHEET NO.

P-03.3