



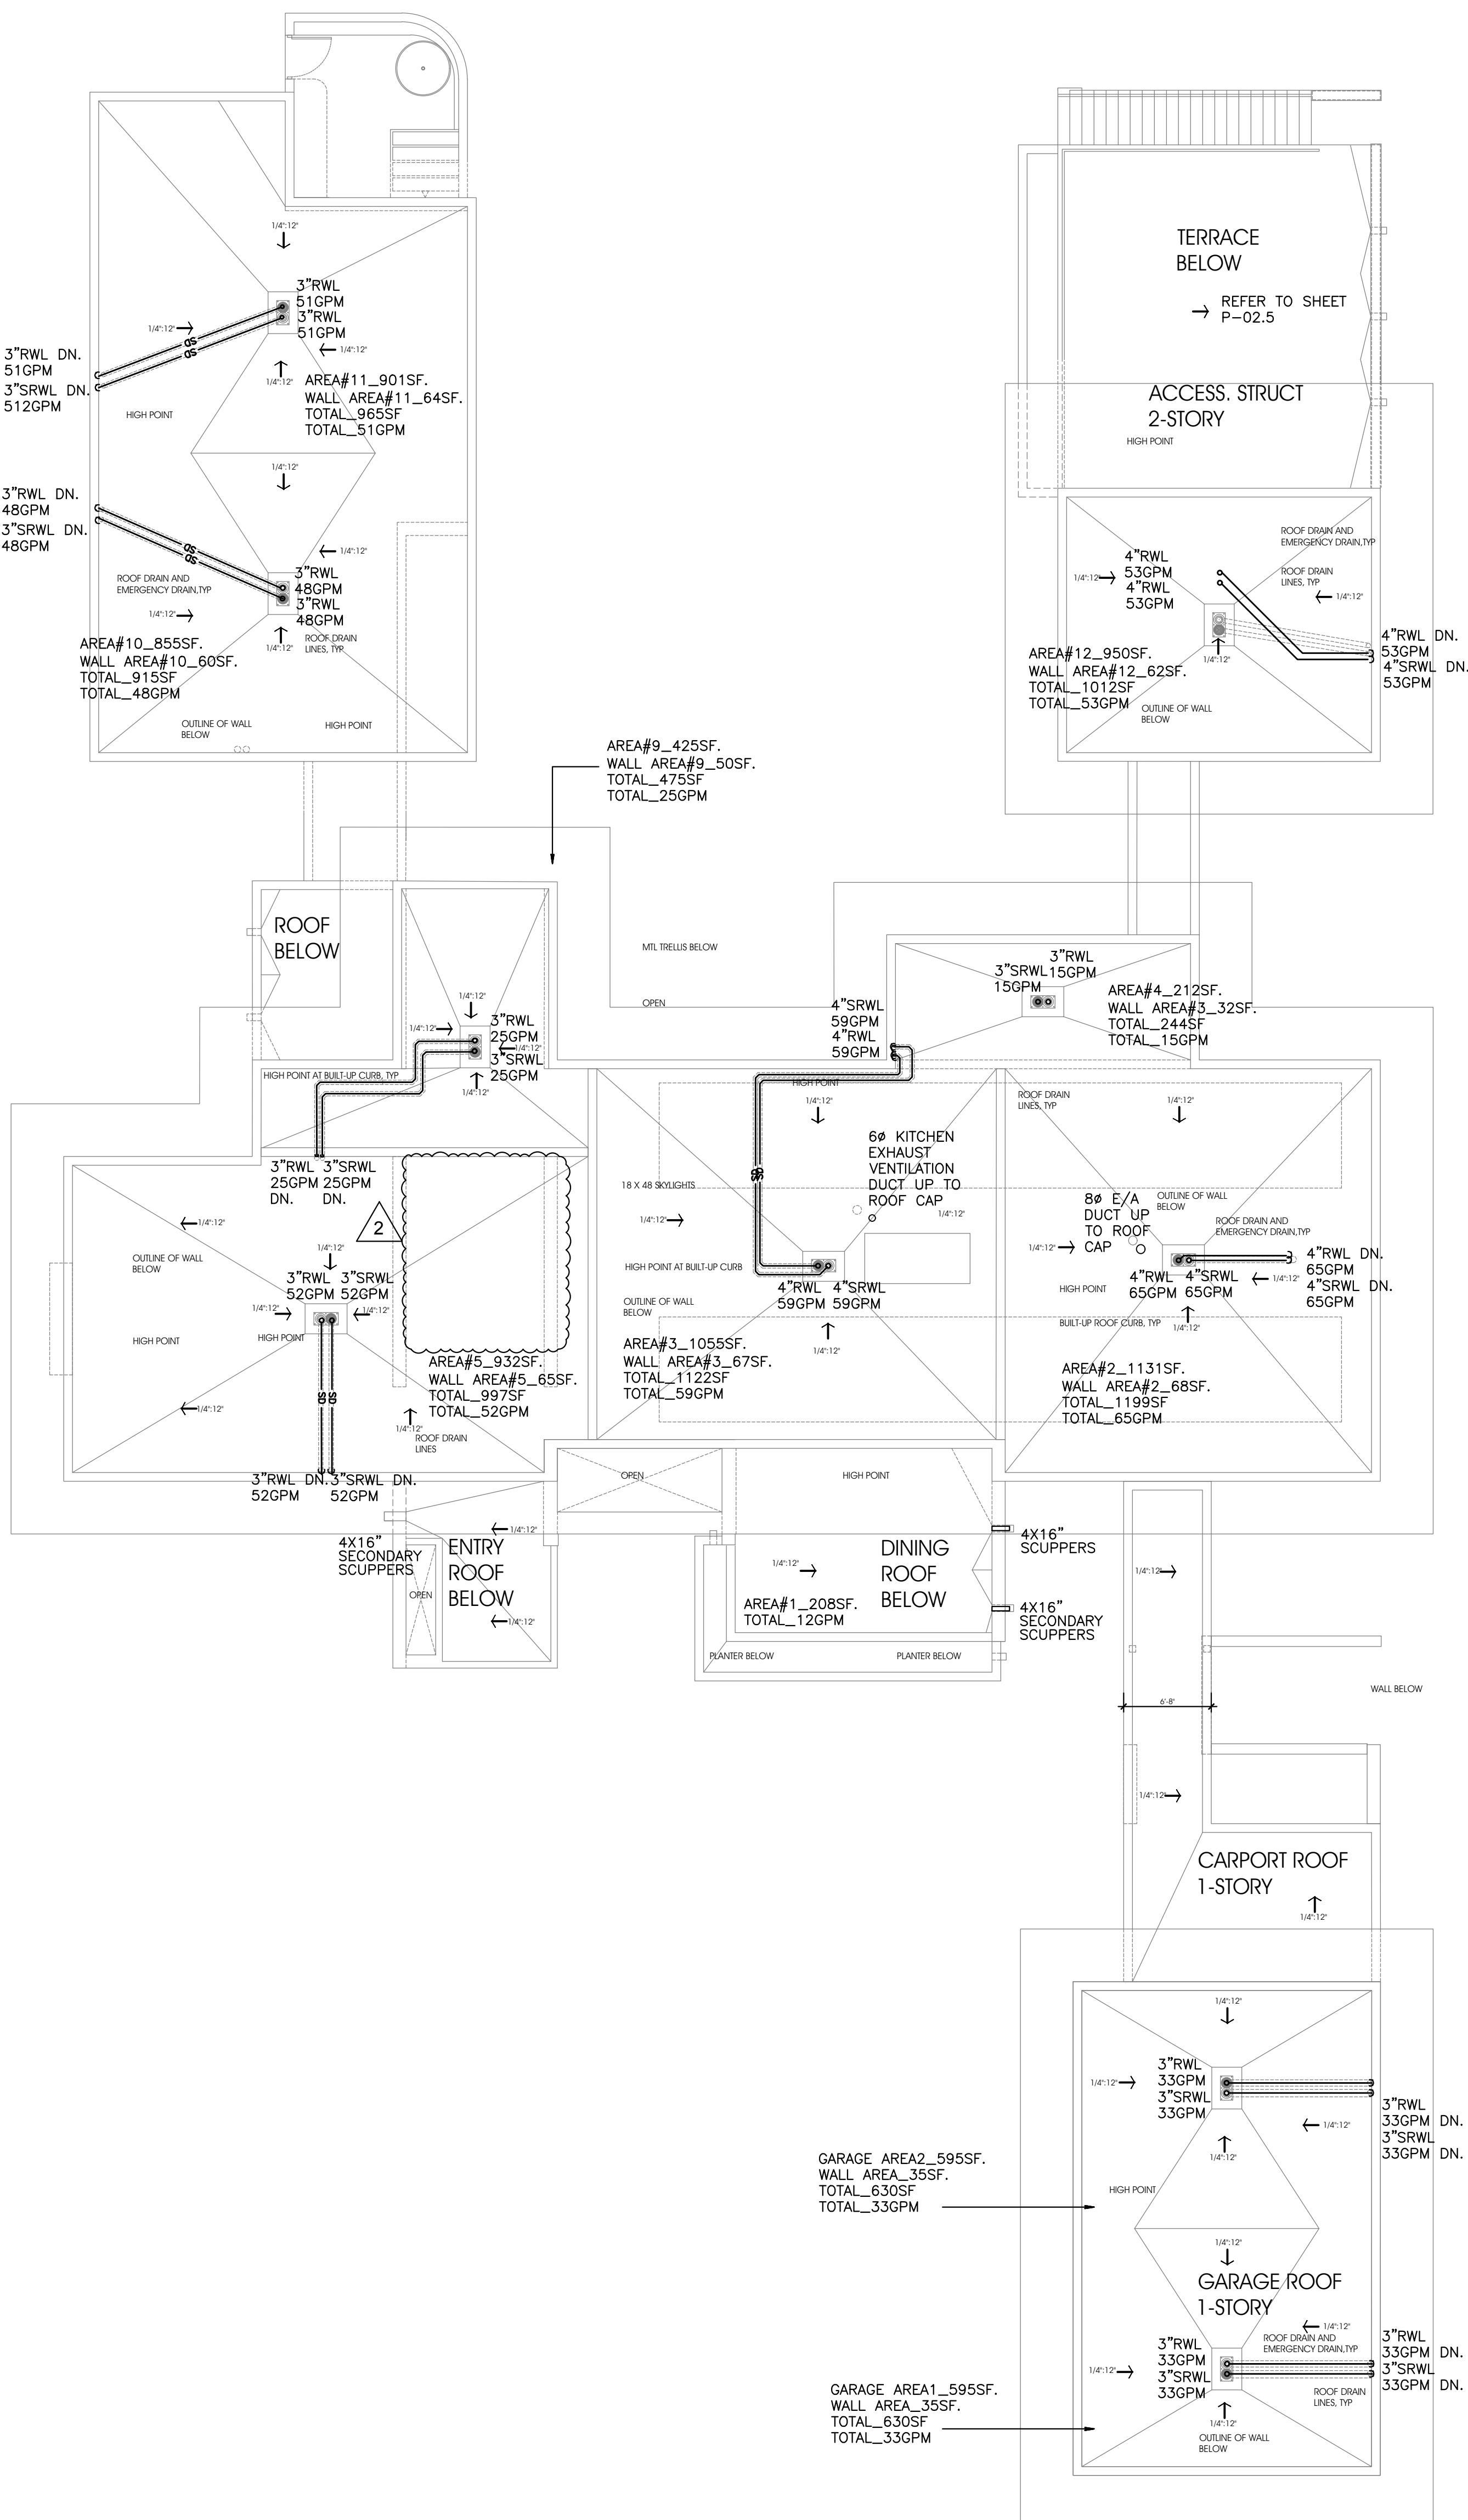

PLUMBING ROOF PLAN

SCALE: 1/8" = 1'-0"

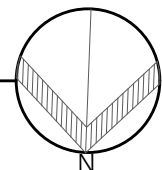

This item has been digitally signed and sealed by Amarilis Rodriguez, P.E. on
Printed copies of this document are not considered signed and
sealed and the signature must be verified on any electronic copies.

JOB# 24-0407



Amarilis Rodriguez, P.E.
License Number 60236
C.A. 26359

2020 Ponce de Leon Blvd., Suite 1002
Coral Gables, Florida 33134
Phone > 305 444 8809
Fax > 305 444 9827

Engineering Design:
> Mechanical > Electrical
> Plumbing > Fire Protection
www.arpe-eng.com

Signature _____
Date _____

NOTES

LOCUS
ARCHITECTURE
INCORPORATED
500 South Dixie Highway, Suite 307
Coral Gables, Florida 33146
Tel: (305) 740-0120
Email: locus@locusarchitecture.net
License: AR 13937

CONSULTANT(S)

NO.	REVISION/SUBMISSION	DATE
	OWNER REVIEW	03-11-24
	PERMIT SUBMITTAL	06-07-24
2	OWNER CHANGES	03-30-26

PROJECT

New 2-Story Residence:
6100 W Suburban Dr, Pinecrest, FL
33156

DRAWING

Plumbing Roof Plan

SEAL

SCALE

As Shown

DRAWN

REVIEWED

Nelson de Leon
AR 13937

PROJ. NO.

351

SHEET NO.

P-04.0