



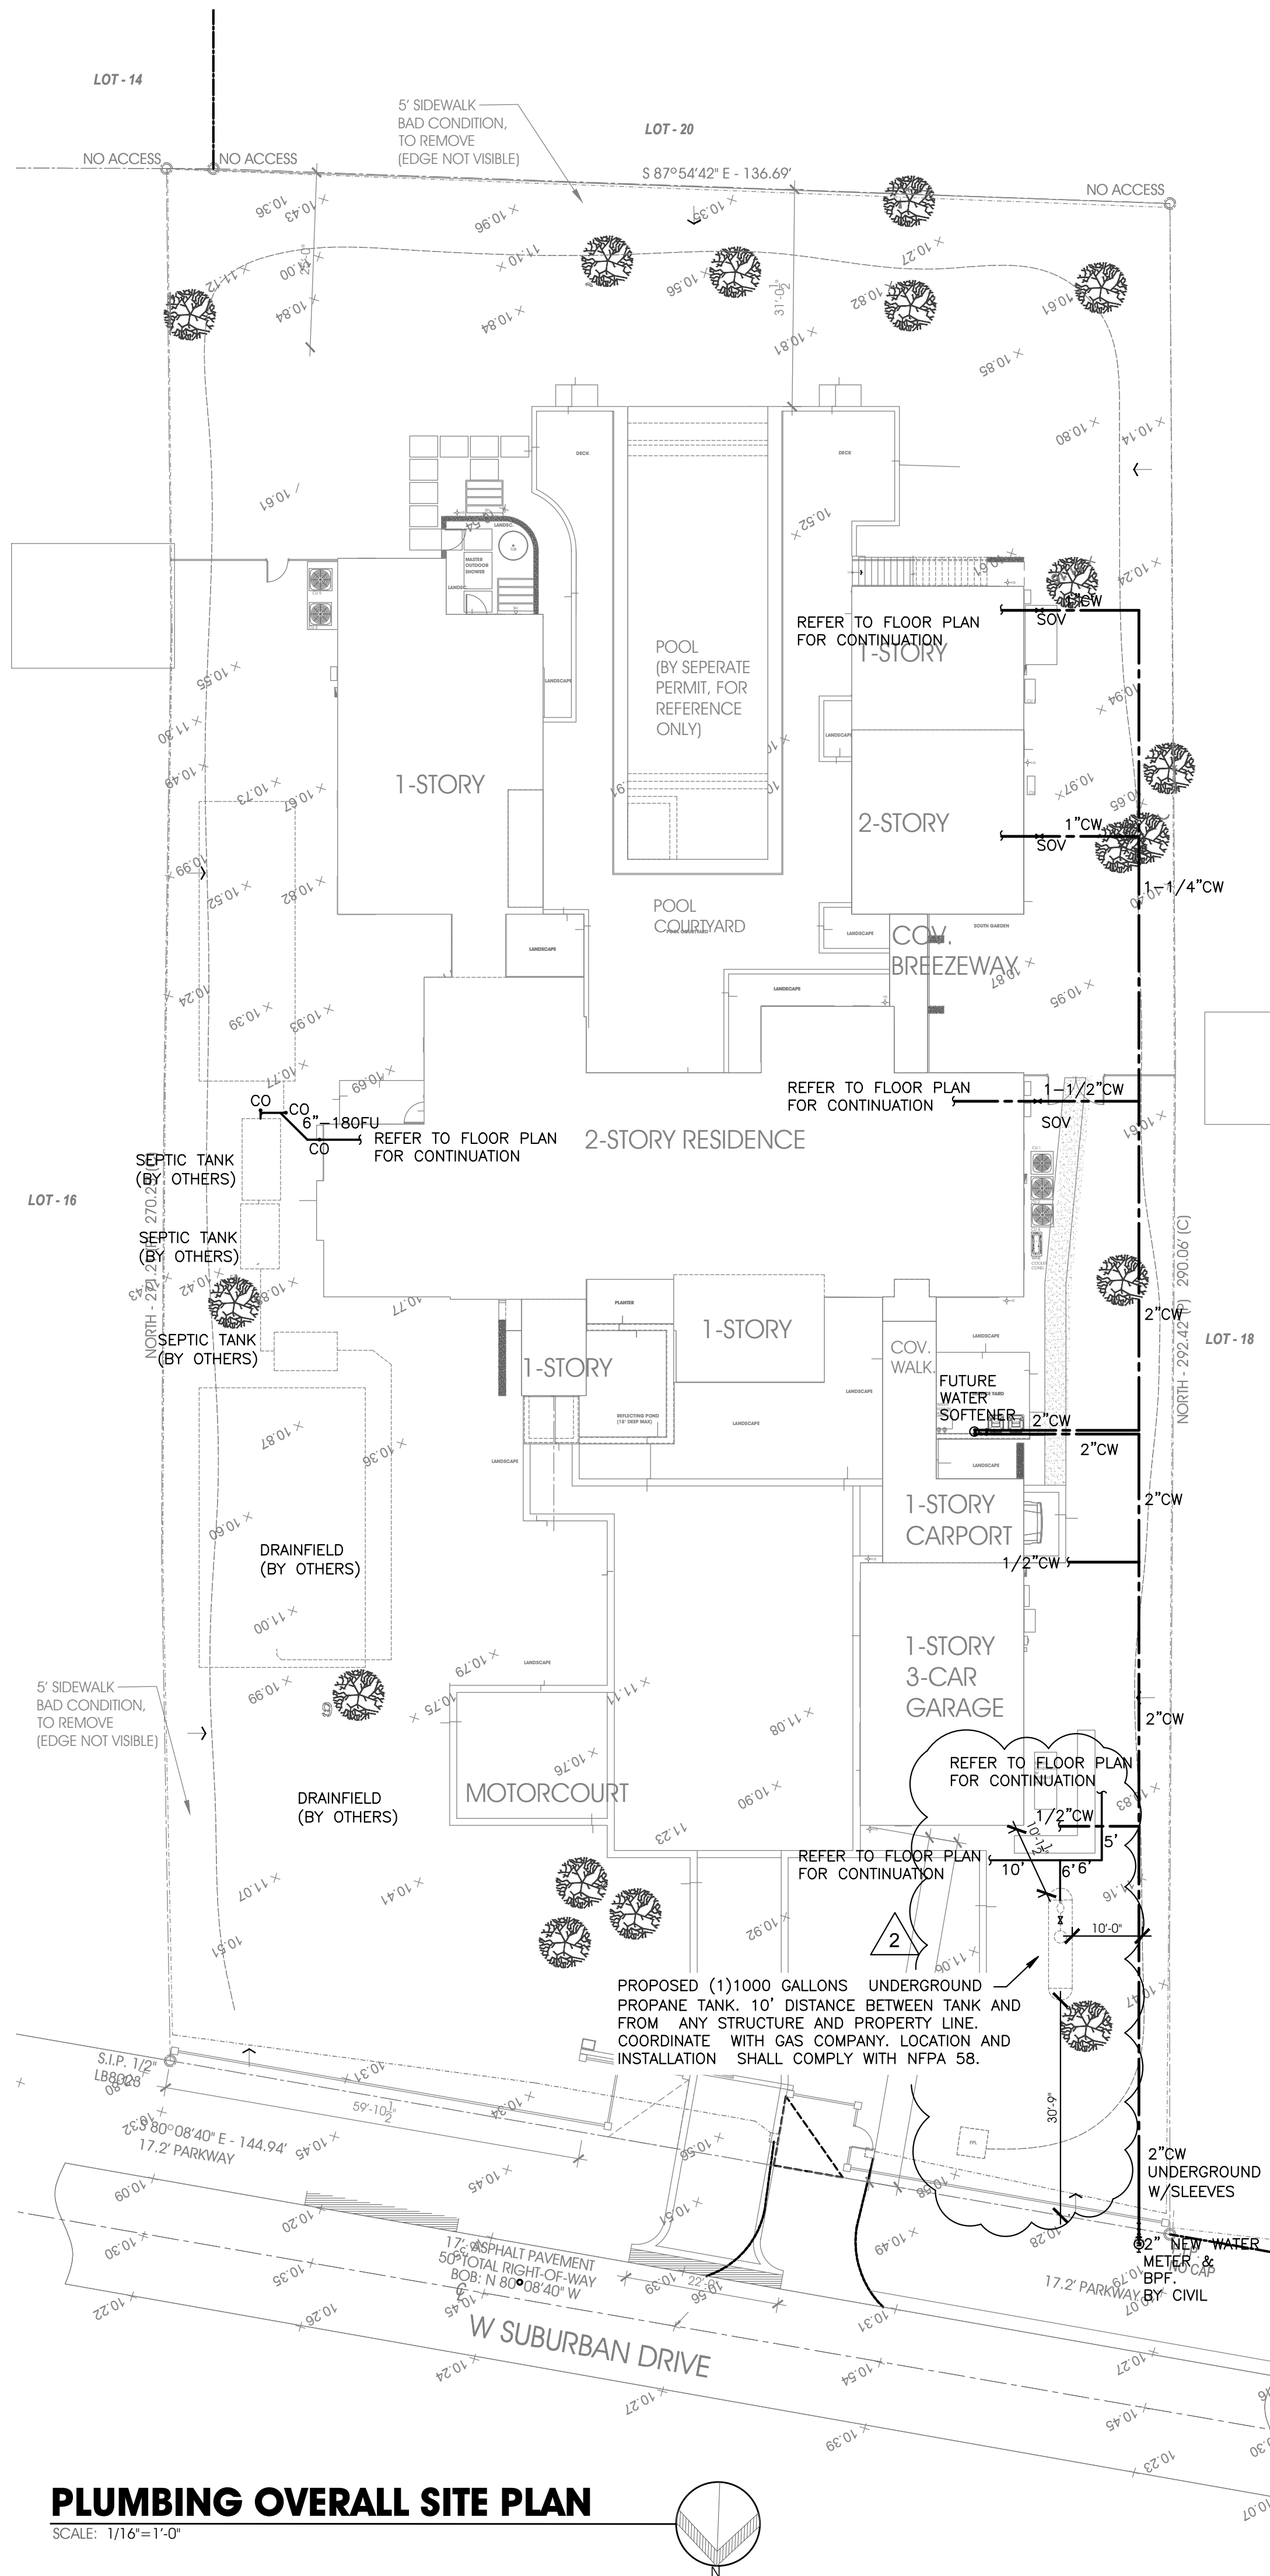

PLUMBING OVERALL SITE PLAN

SCALE: 1/16"=1'-0"

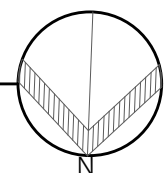

This item has been digitally signed and sealed by Amarilis Rodriguez, P.E. on 03-11-24. Printed copies of this document are not considered signed and sealed and the signature must be verified on any electronic copies. JOB# 24-0407



2020 Ponce de Leon Blvd., Suite 1002
Coral Gables, Florida 33134
Phone > 305 444 8809
Fax > 305 444 9827

Engineering Design:
> Mechanical > Electrical
> Plumbing > Fire Protection
www.arpe-eng.com

Amarilis Rodriguez, P.E.
License Number 60236
C.A. 26359

Signature _____
Date _____

NOTES

LOCUS
ARCHITECTURE
INCORPORATED
500 South Dixie Highway, Suite 307
Coral Gables, Florida 33146
Tel: (305) 740-0120
Email: locus@locusarchitecture.net
License: AR 13937

CONSULTANT(S)

NO.	REVISION/SUBMISSION	DATE
	OWNER REVIEW	03-11-24
	PERMIT SUBMITTAL	06-07-24
2	OWNER CHANGES	03-30-26

PROJECT

New 2-Story Residence:
6100 W Suburban Dr, Pinecrest, FL
33156

DRAWING

Plumbing Site Plan

SEAL	SCALE As Shown
	DRAWN
	REVIEWED
Nelson de Leon AR 13937	PROJ. NO. 351


SHEET NO.

P-01.0

04


04

03

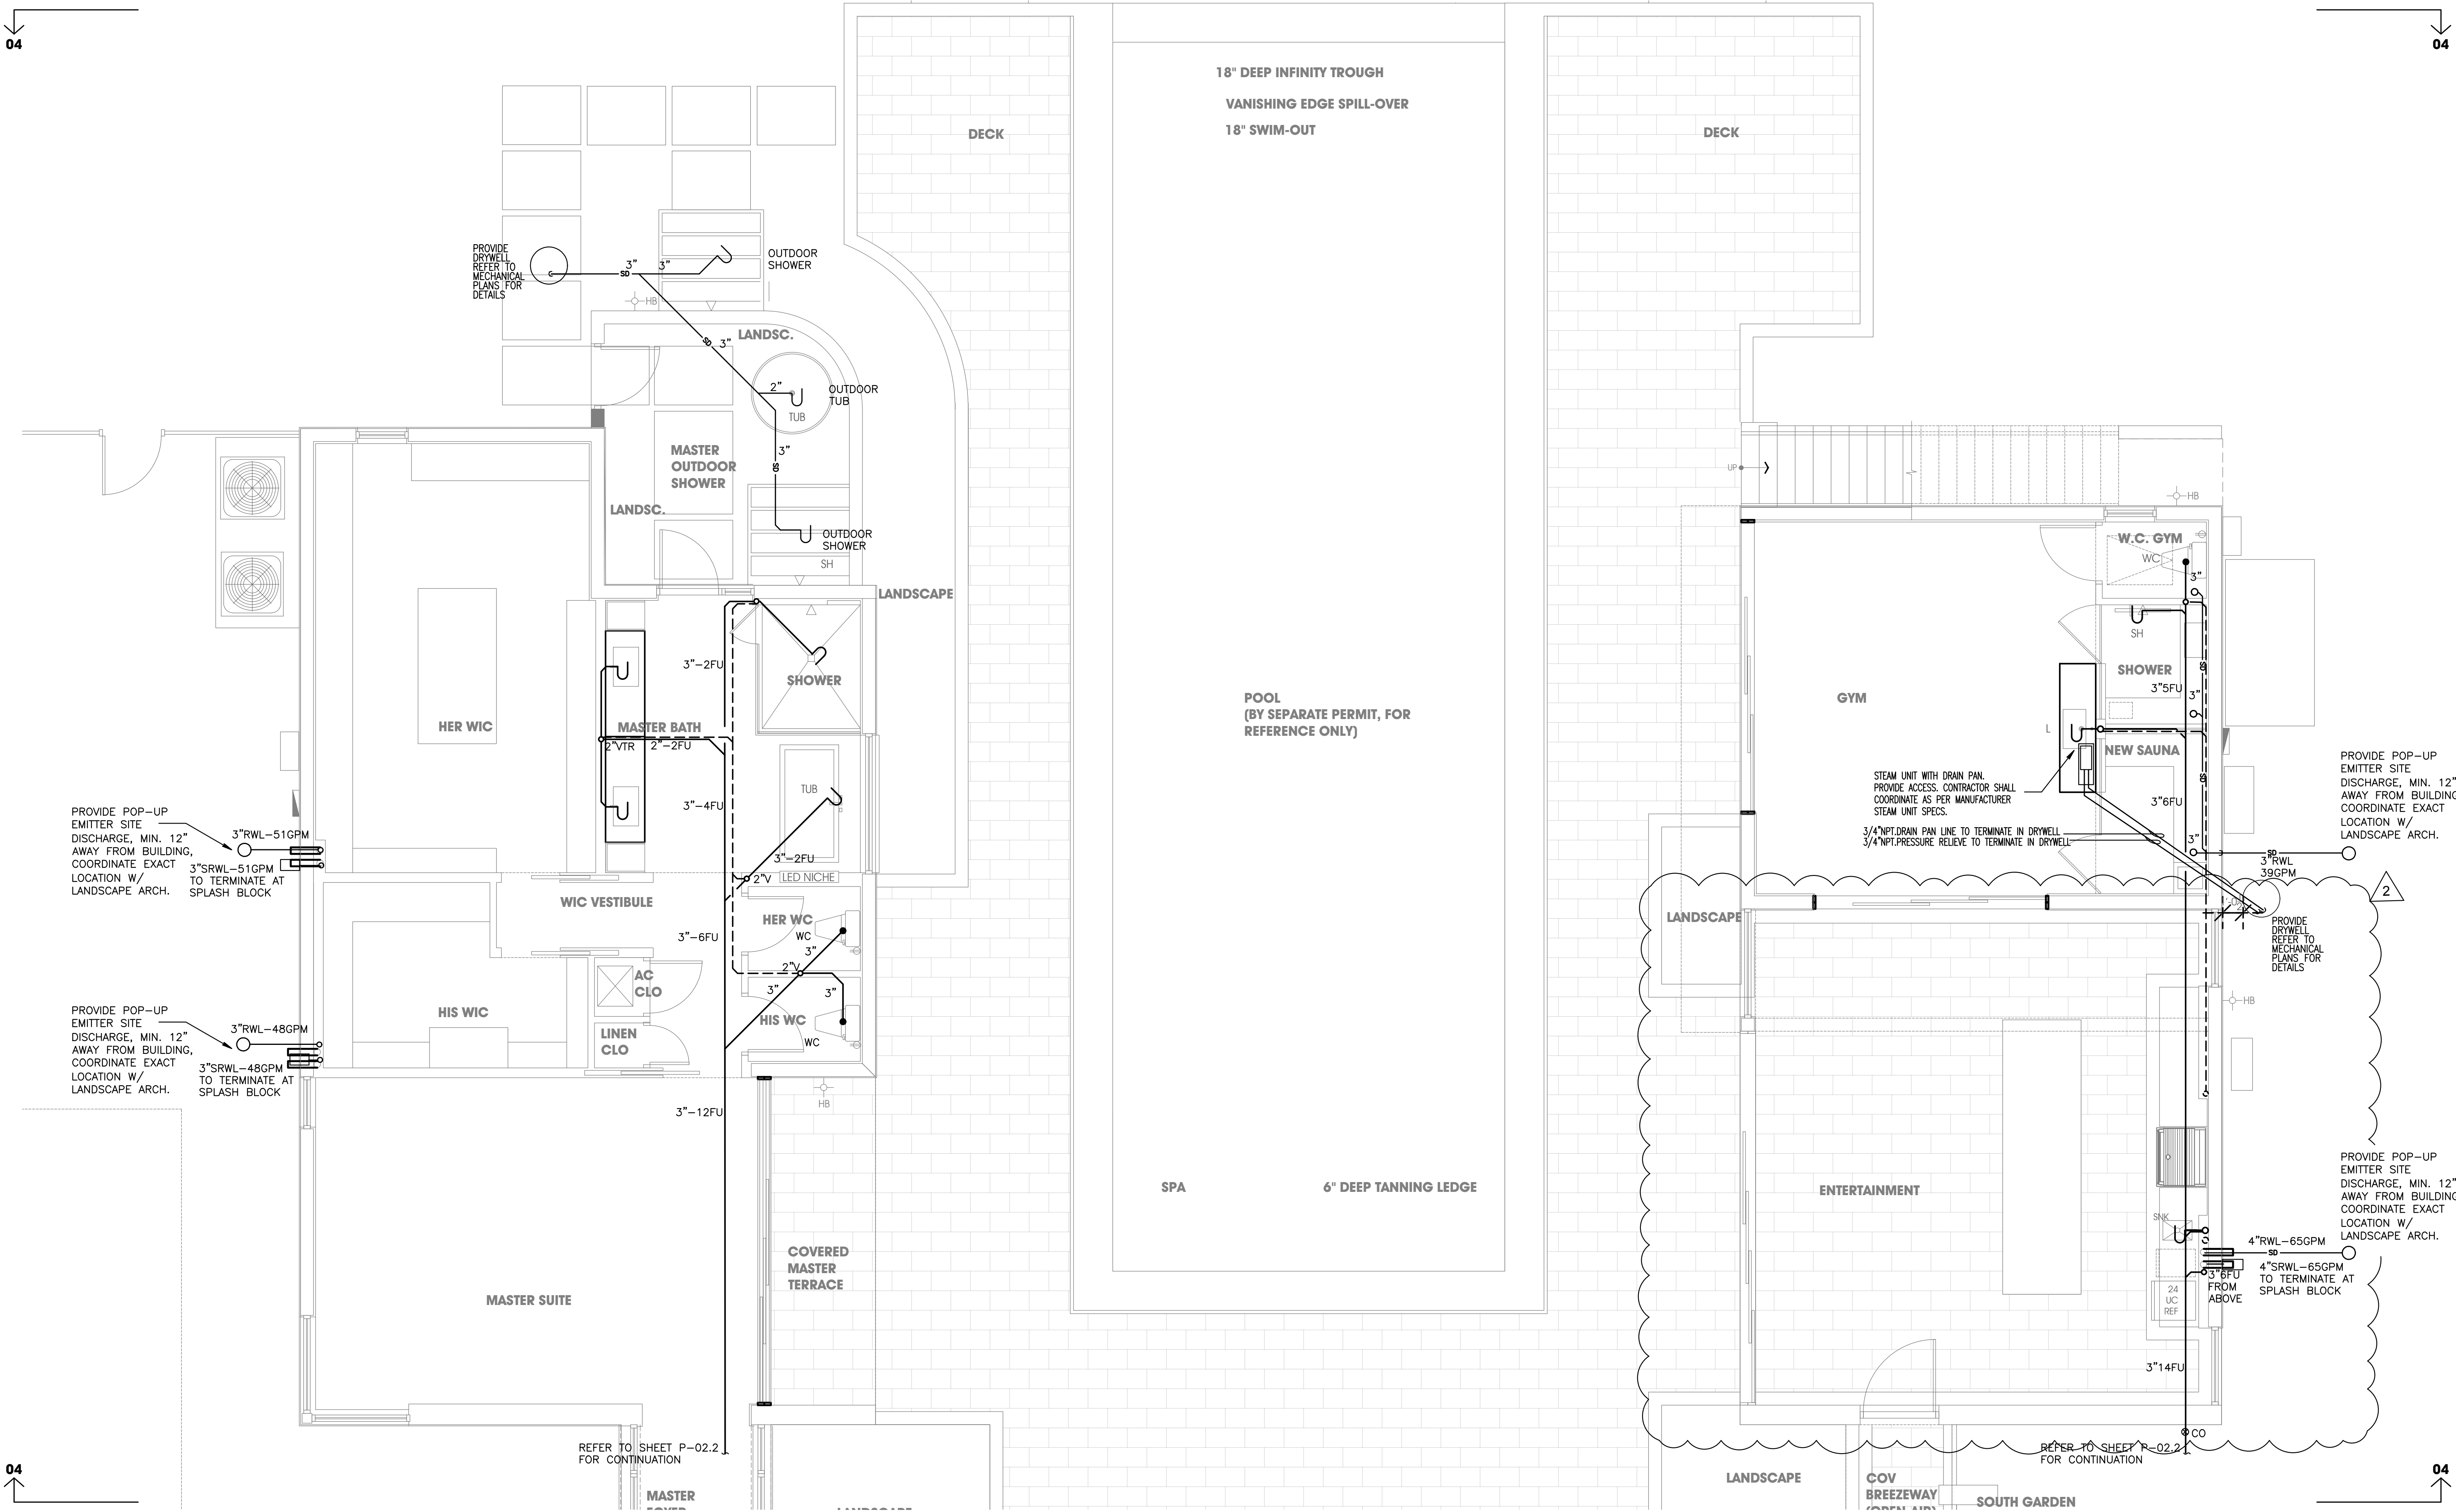

SANITARY & STORM FIRST FLOOR PLAN: 04

SCALE: 1/4" = 1'-0"

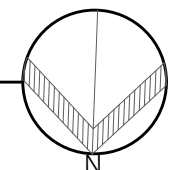

This item has been digitally signed and sealed by Amarilis Rodriguez, PE, on
Printed copies of this document are not considered signed and
sealed and the signature must be verified on any electronic copies.

JOB# 24-0407




Amarilis Rodriguez, P.E.
License Number 60236
C.A. 26359

2020 Ponce de Leon Blvd., Suite 1002
Coral Gables, Florida 33134
Phone > 305 444 8809
Fax > 305 444 9827
Engineering Design:
> Mechanical > Electrical
> Plumbing > Fire Protection
www.arpe-eng.com

Signature _____
Date _____

NOTES

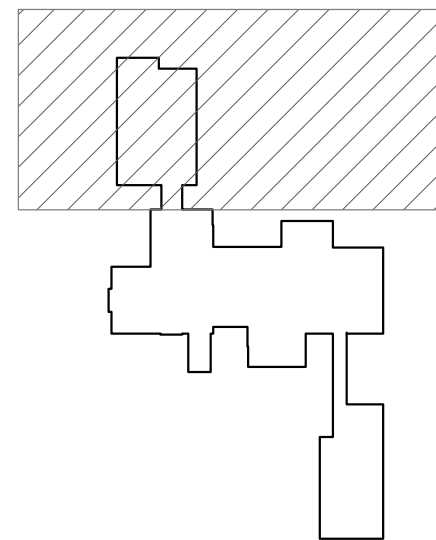

KEY PLAN

SCALE: 1/4" = 1'-0"



500 South Dixie Highway, Suite 307
Coral Gables, Florida 33146
Tel: (305) 740-0120
Email: locus@locusarchitecture.net
License: AR 13937

CONSULTANT(S)

NO.	REVISION/SUBMISSION	DATE
	OWNER REVIEW	03-11-24
	PERMIT SUBMITTAL	06-07-24
2	OWNER CHANGES	03-30-26

PROJECT

New 2-Story Residence:
6100 W Suburban Dr, Pinecrest, FL
33156


DRAWING

Sanitary & Storm First Floor Plan: 04


SEAL	SCALE As Shown
	DRAWN
	REVIEWED
Nelson de Leon AR 13937	PROJ. NO. 351

SHEET NO.

P-02.3

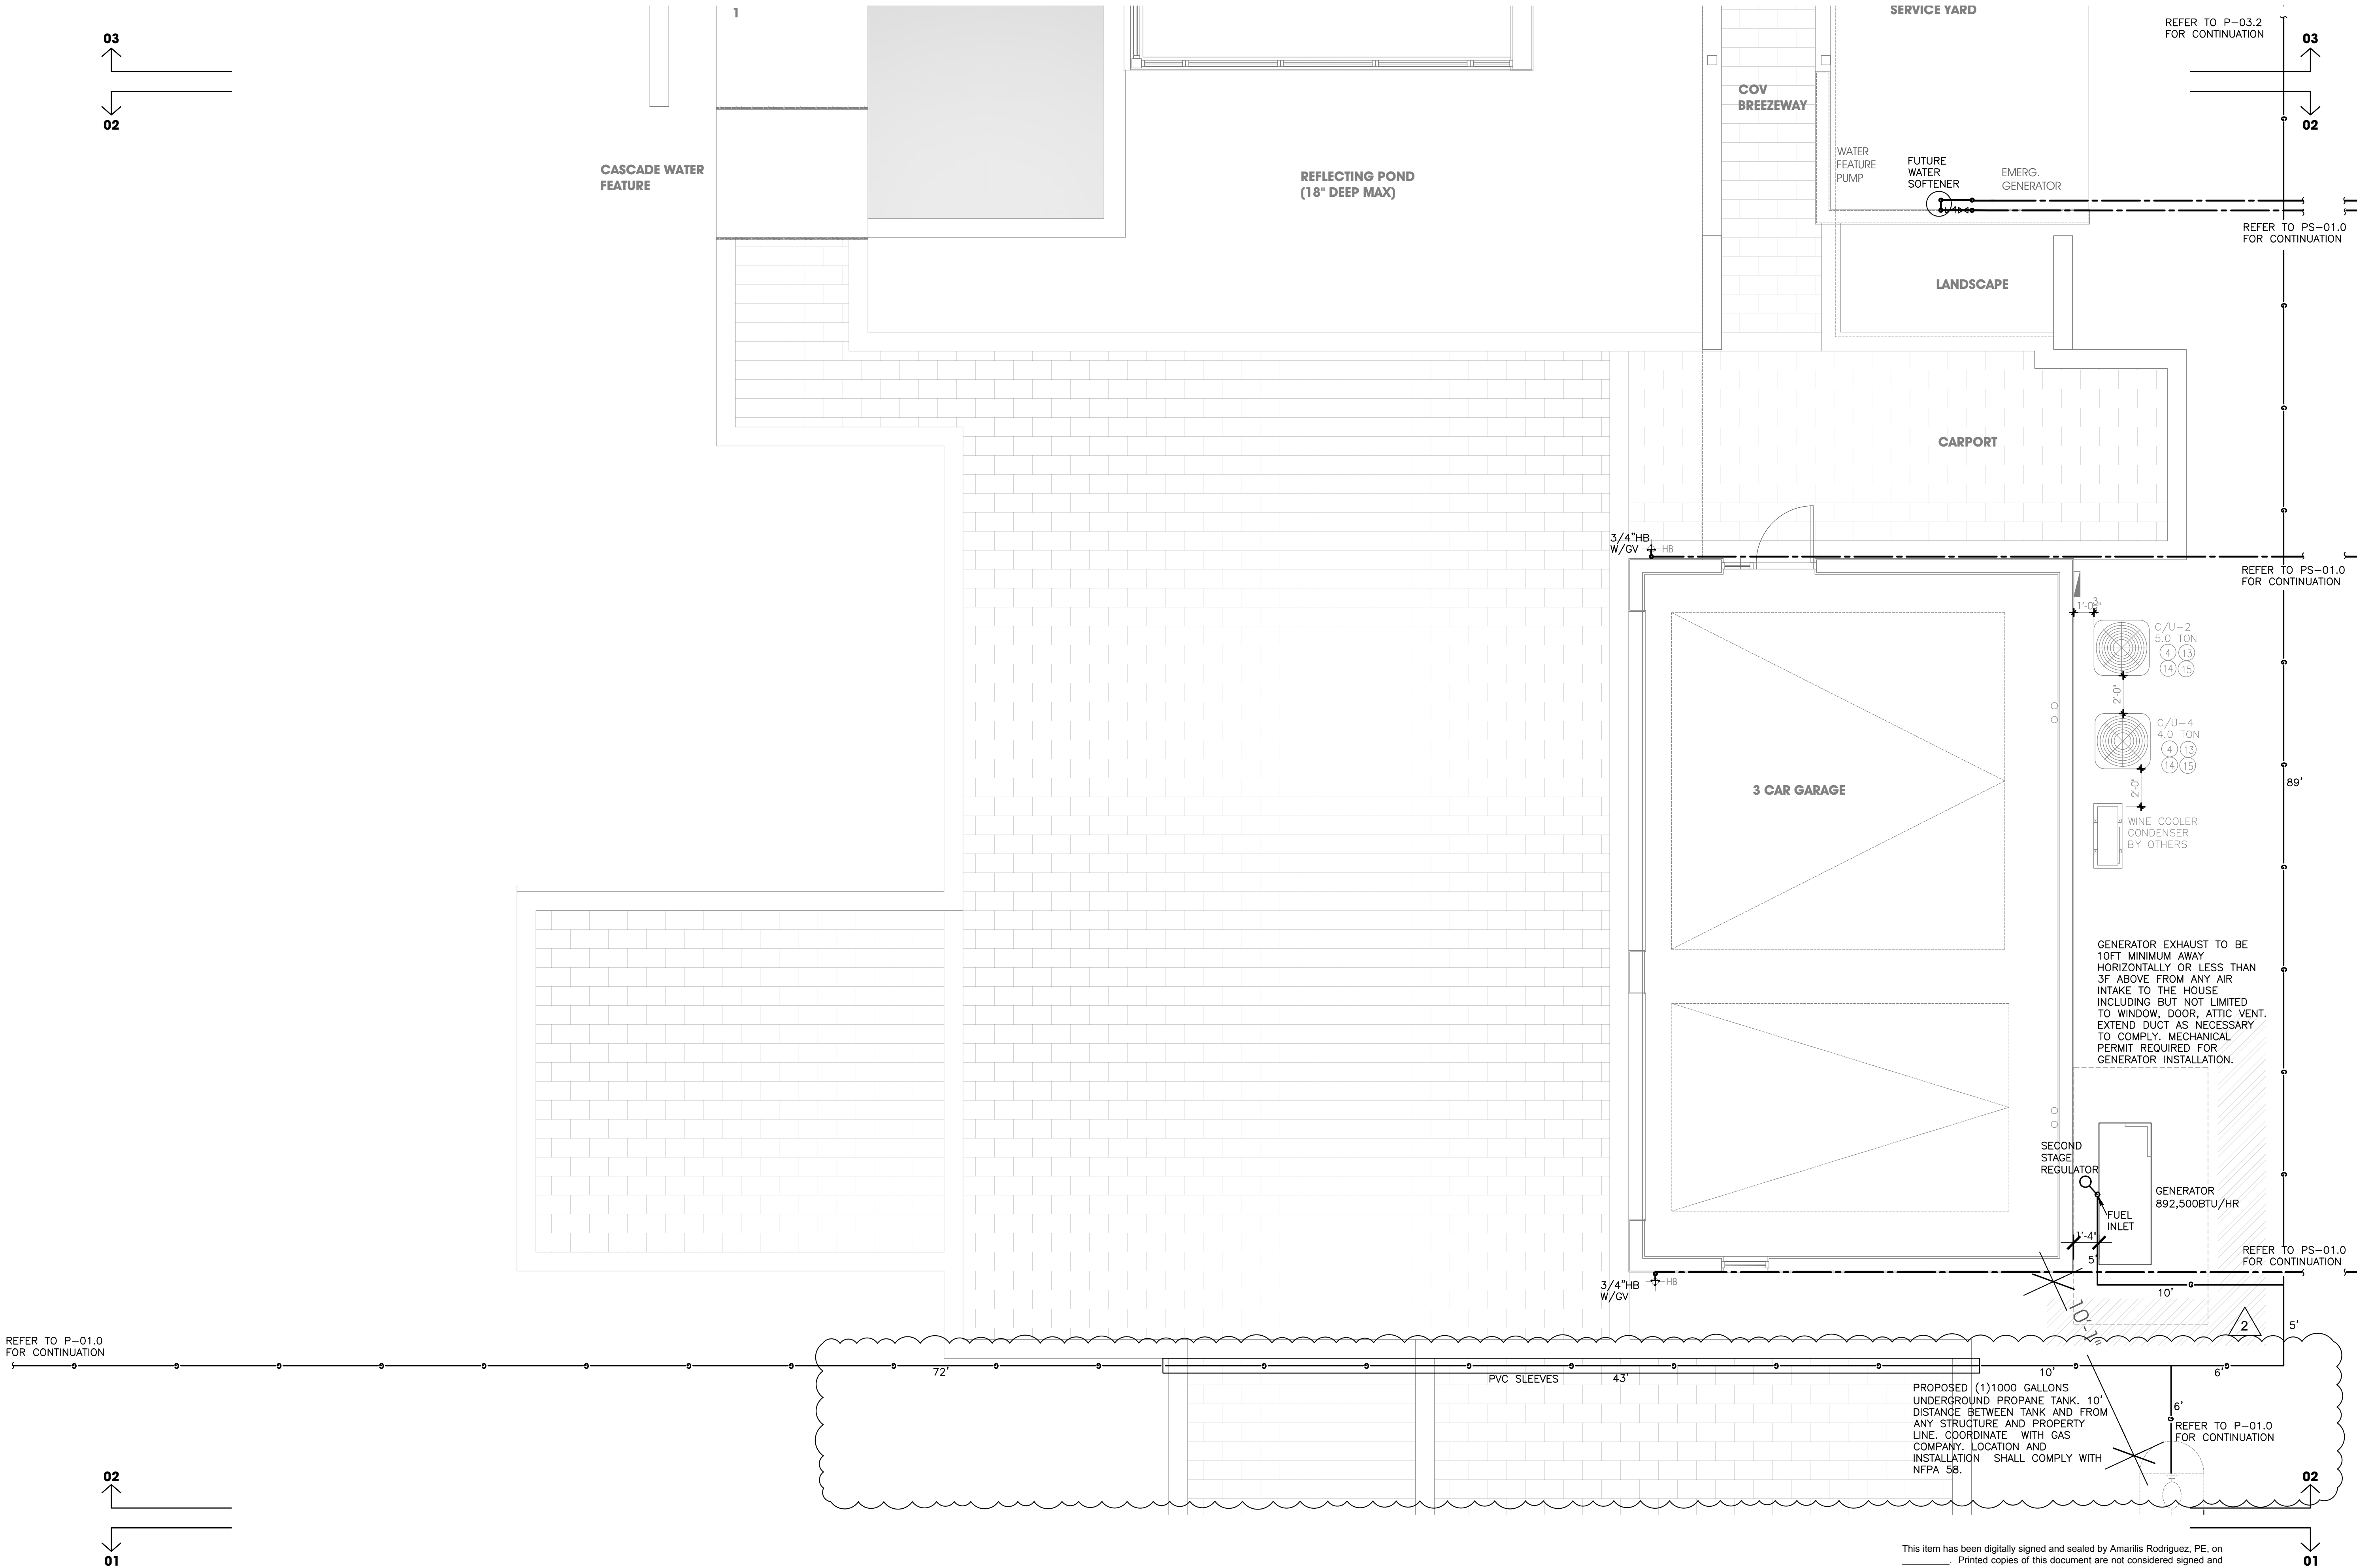

WATER & GAS PARTIAL FIRST FLOOR PLAN: 02
SCALE: 1/4" = 1'-0"

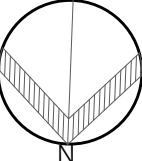

This item has been digitally signed and sealed by Amarilis Rodriguez, P.E. on
Printed copies of this document are not considered signed and
sealed and the signature must be verified on any electronic copies.

JOB# 24-0407




Amarilis Rodriguez, P.E.
License Number 60236
C.A. 26359

2020 Ponce de Leon Blvd., Suite 1002
Coral Gables, Florida 33134
Phone > 305 444 8809
Fax > 305 444 9827
Engineering Design:
> Mechanical > Electrical
> Plumbing > Fire Protection
www.arpe-eng.com

Signature _____
Date _____

NOTES

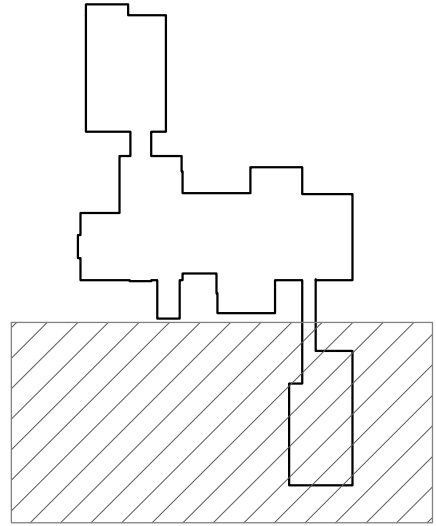

KEY PLAN

SCALE: 1/4" = 1'-0"



500 South Dixie Highway, Suite 307
Coral Gables, Florida 33146
Tel: (305) 740-0120
Email: locus@locusarchitecture.net
License: AR 13937

CONSULTANT(S)

NO.	REVISION/SUBMISSION	DATE
	OWNER REVIEW	03-11-24
	PERMIT SUBMITTAL	06-07-24
2	OWNER CHANGES	03-30-26

PROJECT

New 2-Story Residence:
6100 W Suburban Dr, Pinecrest, FL
33156

DRAWING

Partial First Floor Plan: 02

SEAL	SCALE
	As Shown
DRAWN	
REVIEWED	
Nelson de Leon AR 13937	PROJ. NO. 351

SHEET NO.

P-03.1

04


04

04


03

04

03

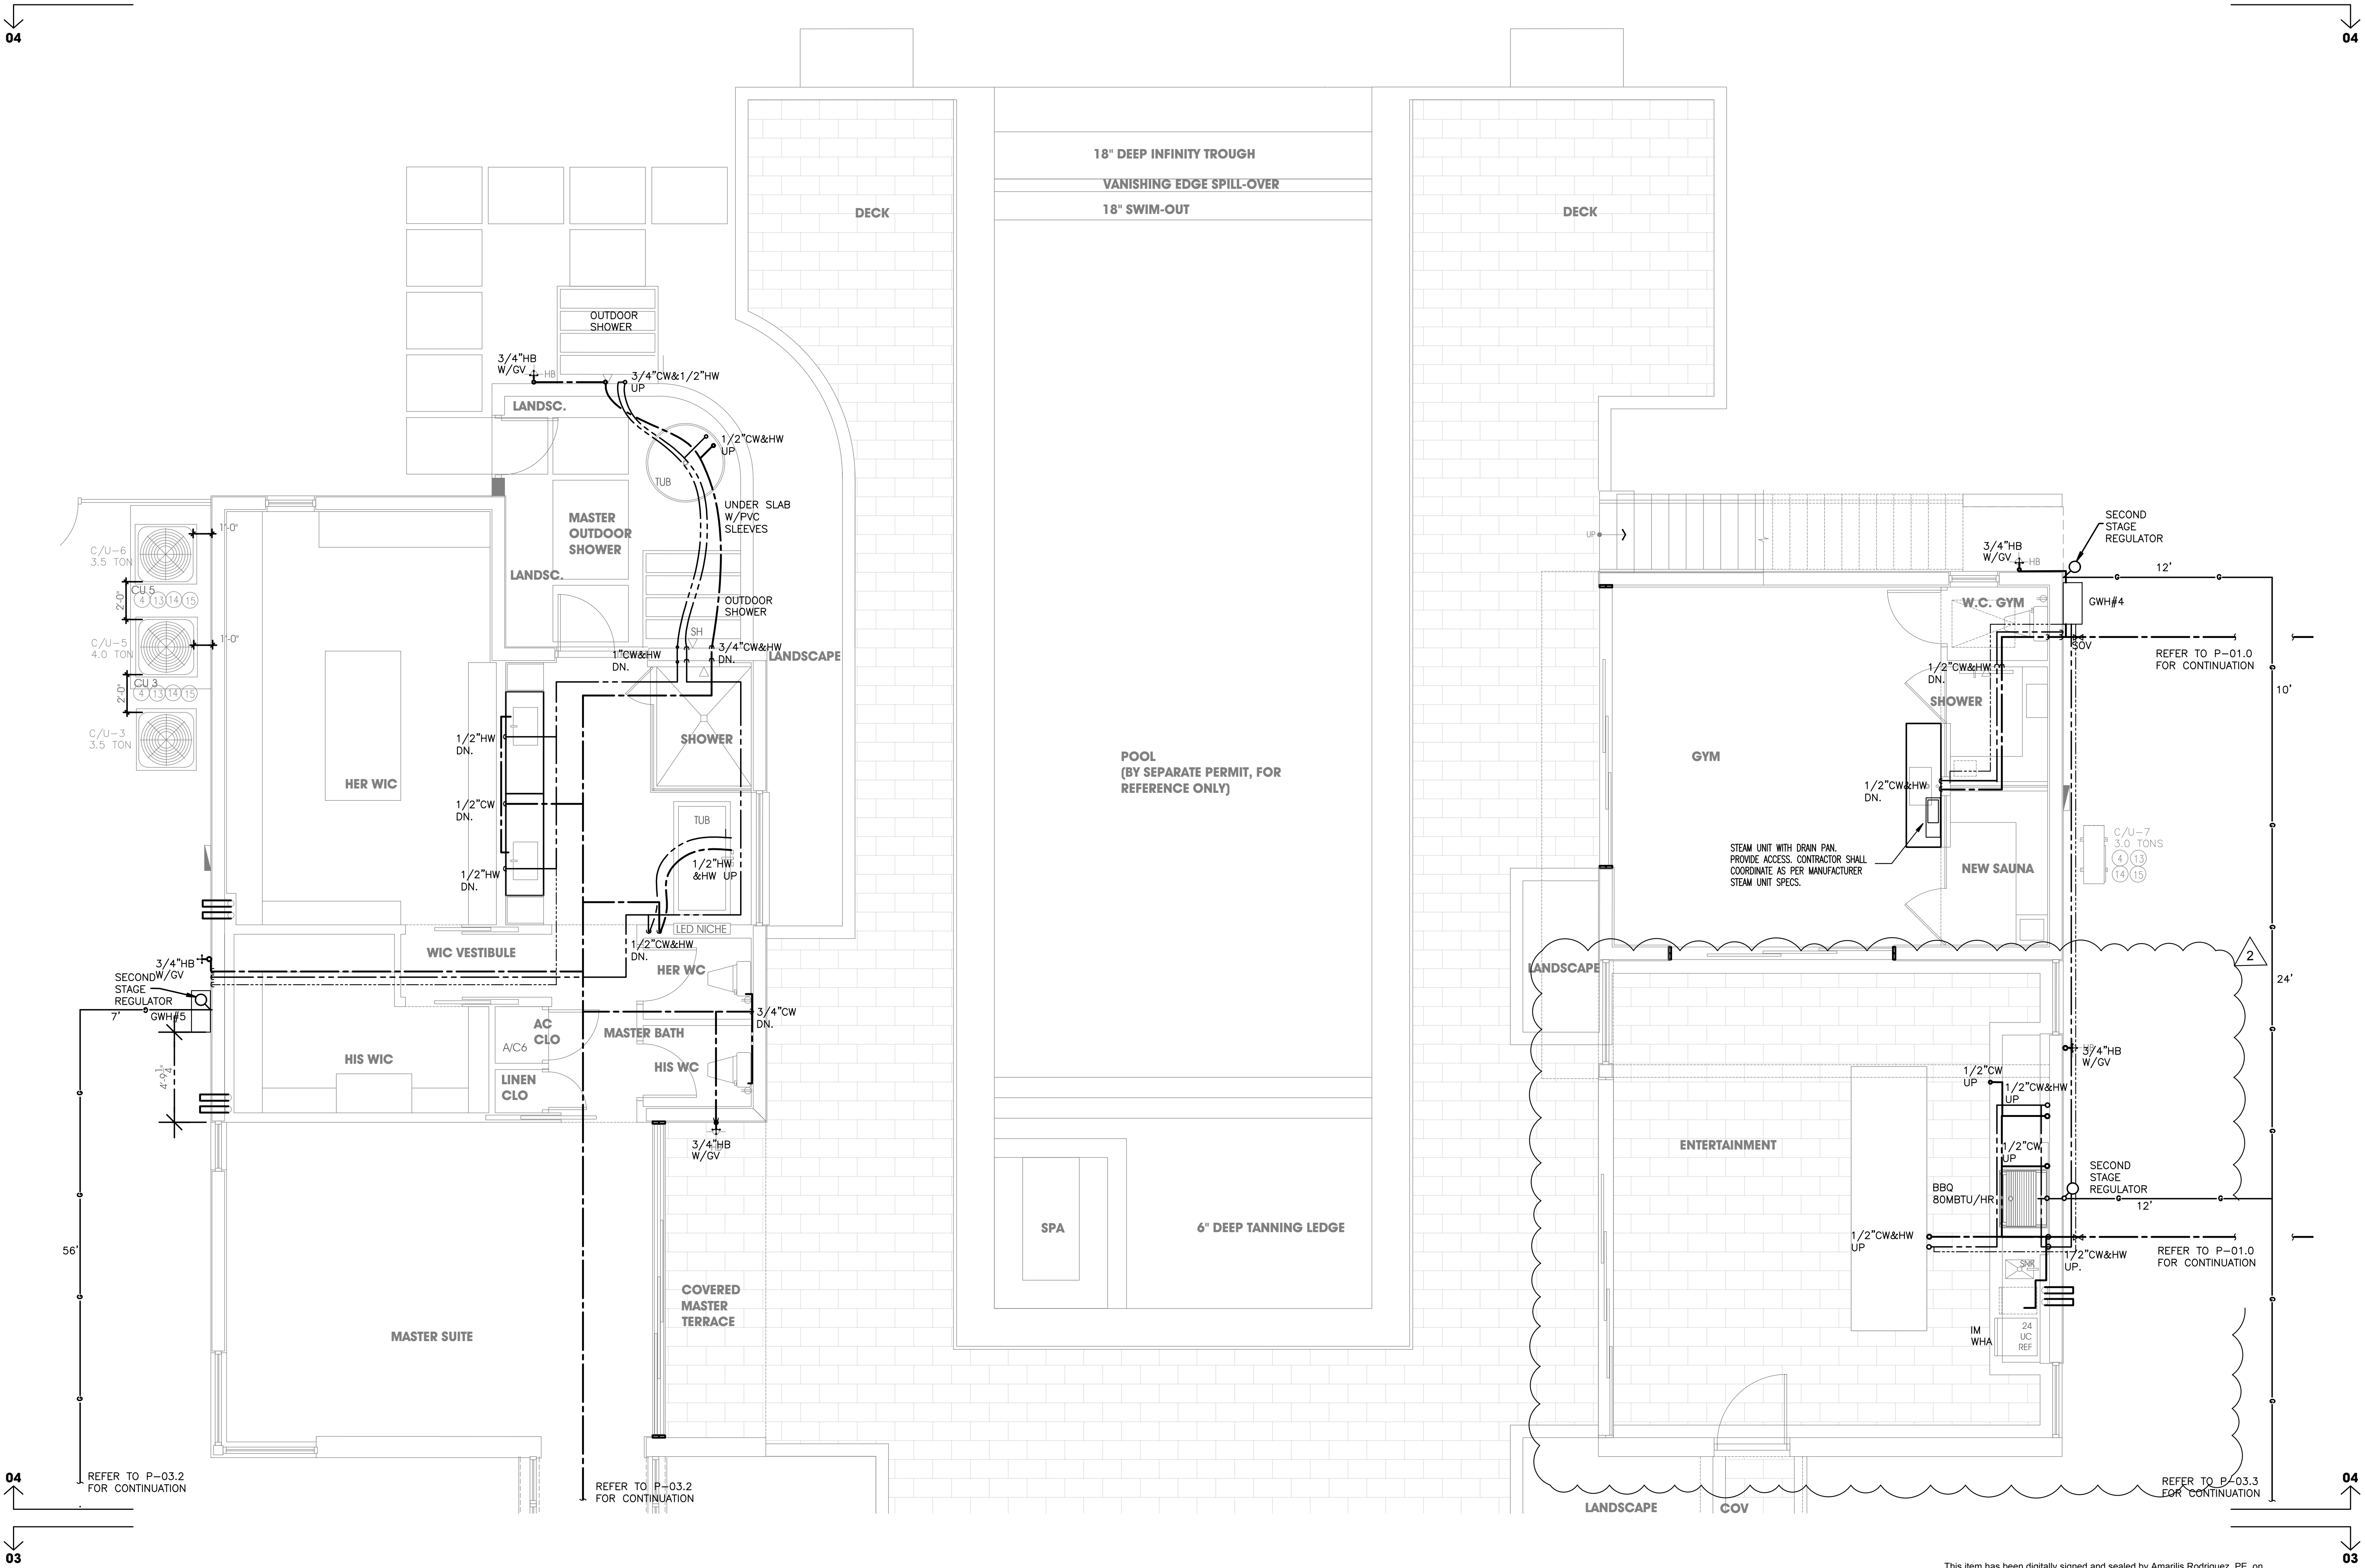


WATER & GAS PARTIAL FIRST FLOOR PLAN: 04
SCALE: 1/4" = 1'-0"

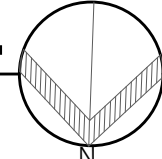

This item has been digitally signed and sealed by Amarilis Rodriguez, P.E. on
Printed copies of this document are not considered signed and
sealed and the signature must be verified on any electronic copies. JOB# 24-0407

 2020 Ponce de Leon Blvd., Suite 1002 Coral Gables, Florida 33134 Phone > 305 444 8809 Fax > 305 444 9827	Amarilis Rodriguez, P.E. License Number 60236 C.A. 26359	
	Engineering Design: > Mechanical > Electrical > Plumbing > Fire Protection www.arpe-eng.com	Signature _____ Date _____

NOTES

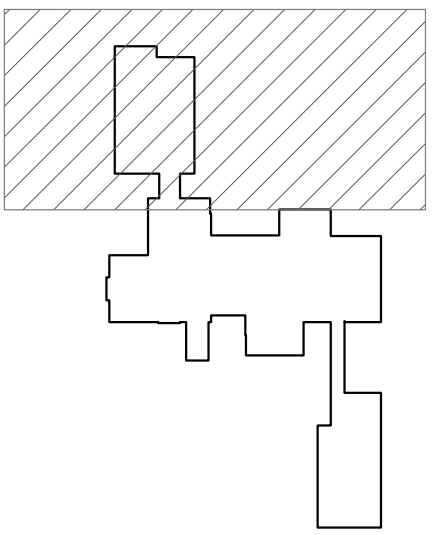

KEY PLAN
SCALE: 1/4" = 1'-0"

LOCUS
ARCHITECTURE
INCORPORATED
500 South Dixie Highway, Suite 307
Coral Gables, Florida 33146
Tel. (305) 740-0120
Email: locus@locusarchitecture.net
License AR 13937

CONSULTANT(S)

NO.	REVISION/SUBMISSION	DATE
	OWNER REVIEW	03-11-24
	PERMIT SUBMITTAL	06-07-24
2	OWNER CHANGES	03-30-26

PROJECT

New 2-Story Residence:
6100 W Suburban Dr, Pinecrest, FL
33156


DRAWING

Partial First Floor Plan: 04

SEAL	SCALE As Shown
	DRAWN
	REVIEWED
Nelson de Leon AR 13937	PROJ. NO. 351


SHEET NO.

P-03.3

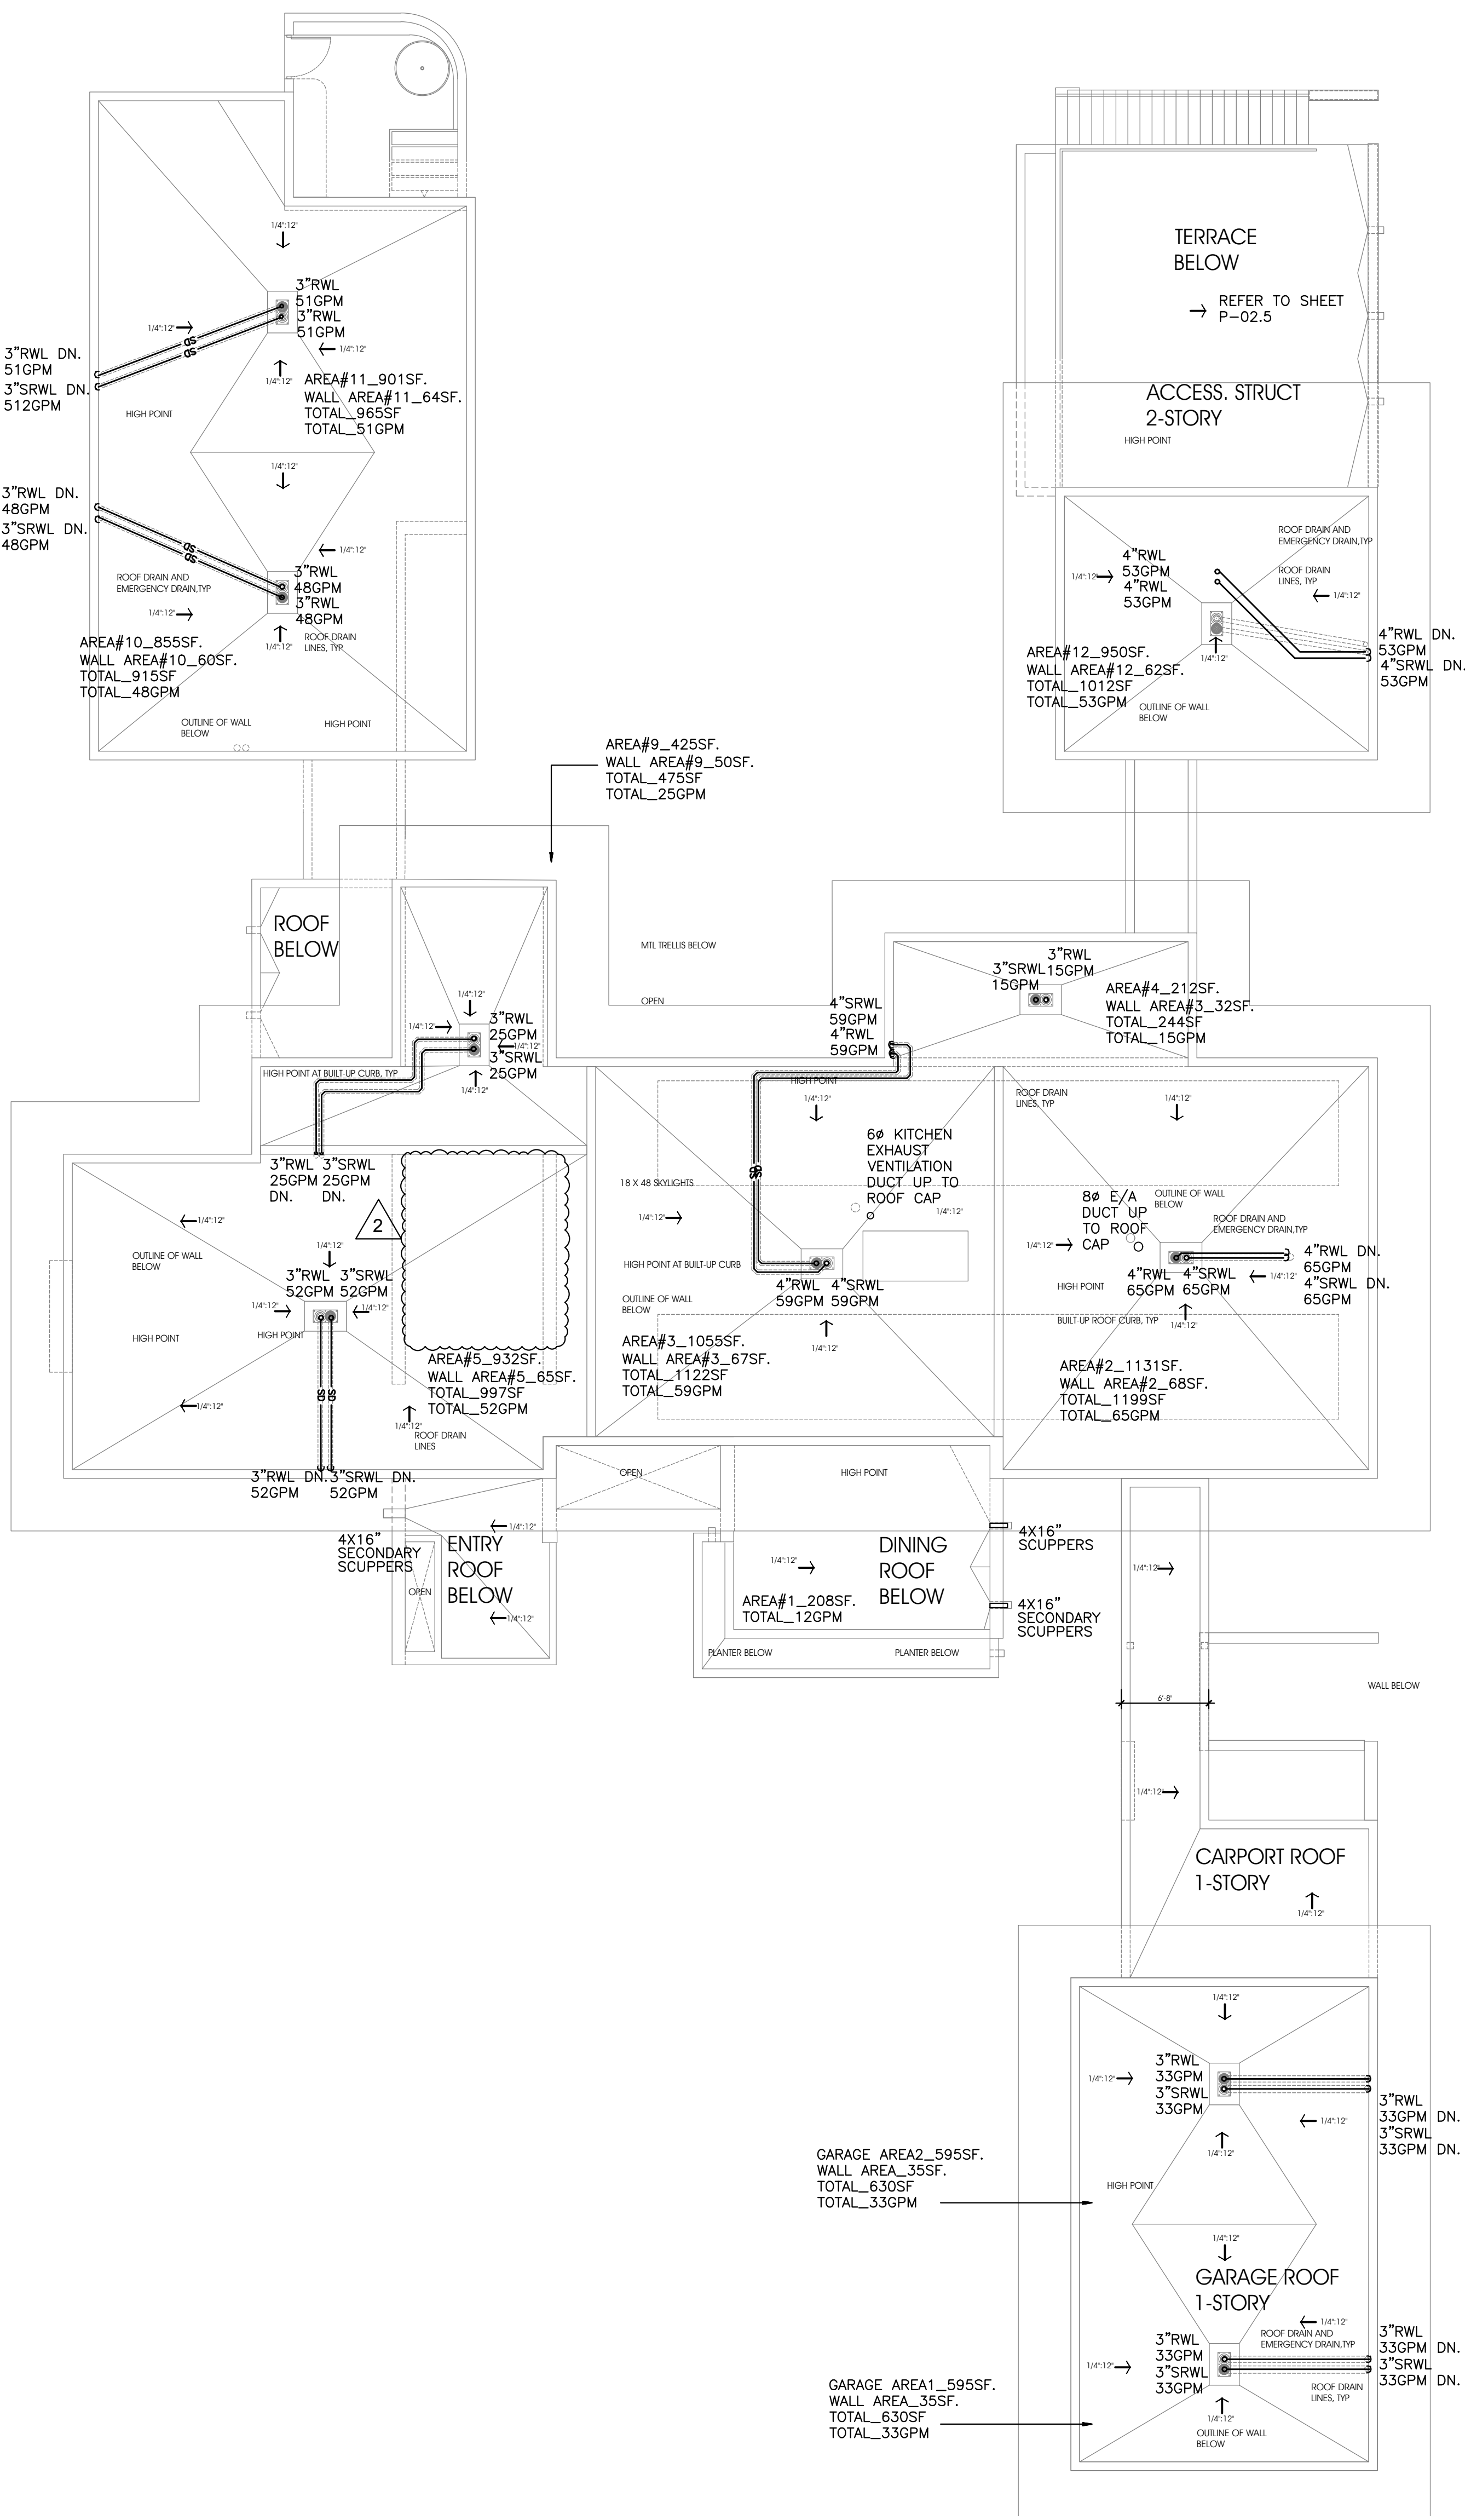

PLUMBING ROOF PLAN

SCALE: 1/8" = 1'-0"

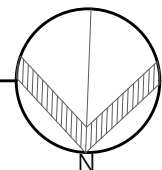

This item has been digitally signed and sealed by Amarilis Rodriguez, P.E. on
Printed copies of this document are not considered signed and
sealed and the signature must be verified on any electronic copies.

JOB# 24-0407



Amarilis Rodriguez, P.E.
License Number 60236
C.A. 26359

2020 Ponce de Leon Blvd., Suite 1002
Coral Gables, Florida 33134
Phone > 305 444 8809
Fax > 305 444 9827
Engineering Design:
> Mechanical > Electrical
> Plumbing > Fire Protection
www.arpe-eng.com

Signature _____
Date _____

NOTES

LOCUS
ARCHITECTURE
INCORPORATED
500 South Dixie Highway, Suite 307
Coral Gables, Florida 33146
Tel: (305) 740-0120
Email: locus@locusarchitecture.net
License: AR 13937

CONSULTANT(S)

NO.	REVISION/SUBMISSION	DATE
	OWNER REVIEW	03-11-24
	PERMIT SUBMITTAL	06-07-24
2	OWNER CHANGES	03-30-26

PROJECT

New 2-Story Residence:
6100 W Suburban Dr, Pinecrest, FL
33156

DRAWING

Plumbing Roof Plan

SEAL

SCALE

As Shown

DRAWN

REVIEWED

Nelson de Leon
AR 13937

PROJ. NO.
351

SHEET NO.

P-04.0

NO.	REVISION/SUBMISSION	DATE
	OWNER REVIEW	03-11-24
	PERMIT SUBMITTAL	06-07-24
2	OWNER CHANGES	03-30-26


New 2-Story Residence:
6100 W Suburban Dr, Pinecrest, FL 33156

Gas Isometric Plan

As Shown

Nelson de Leon
AR 13937

351

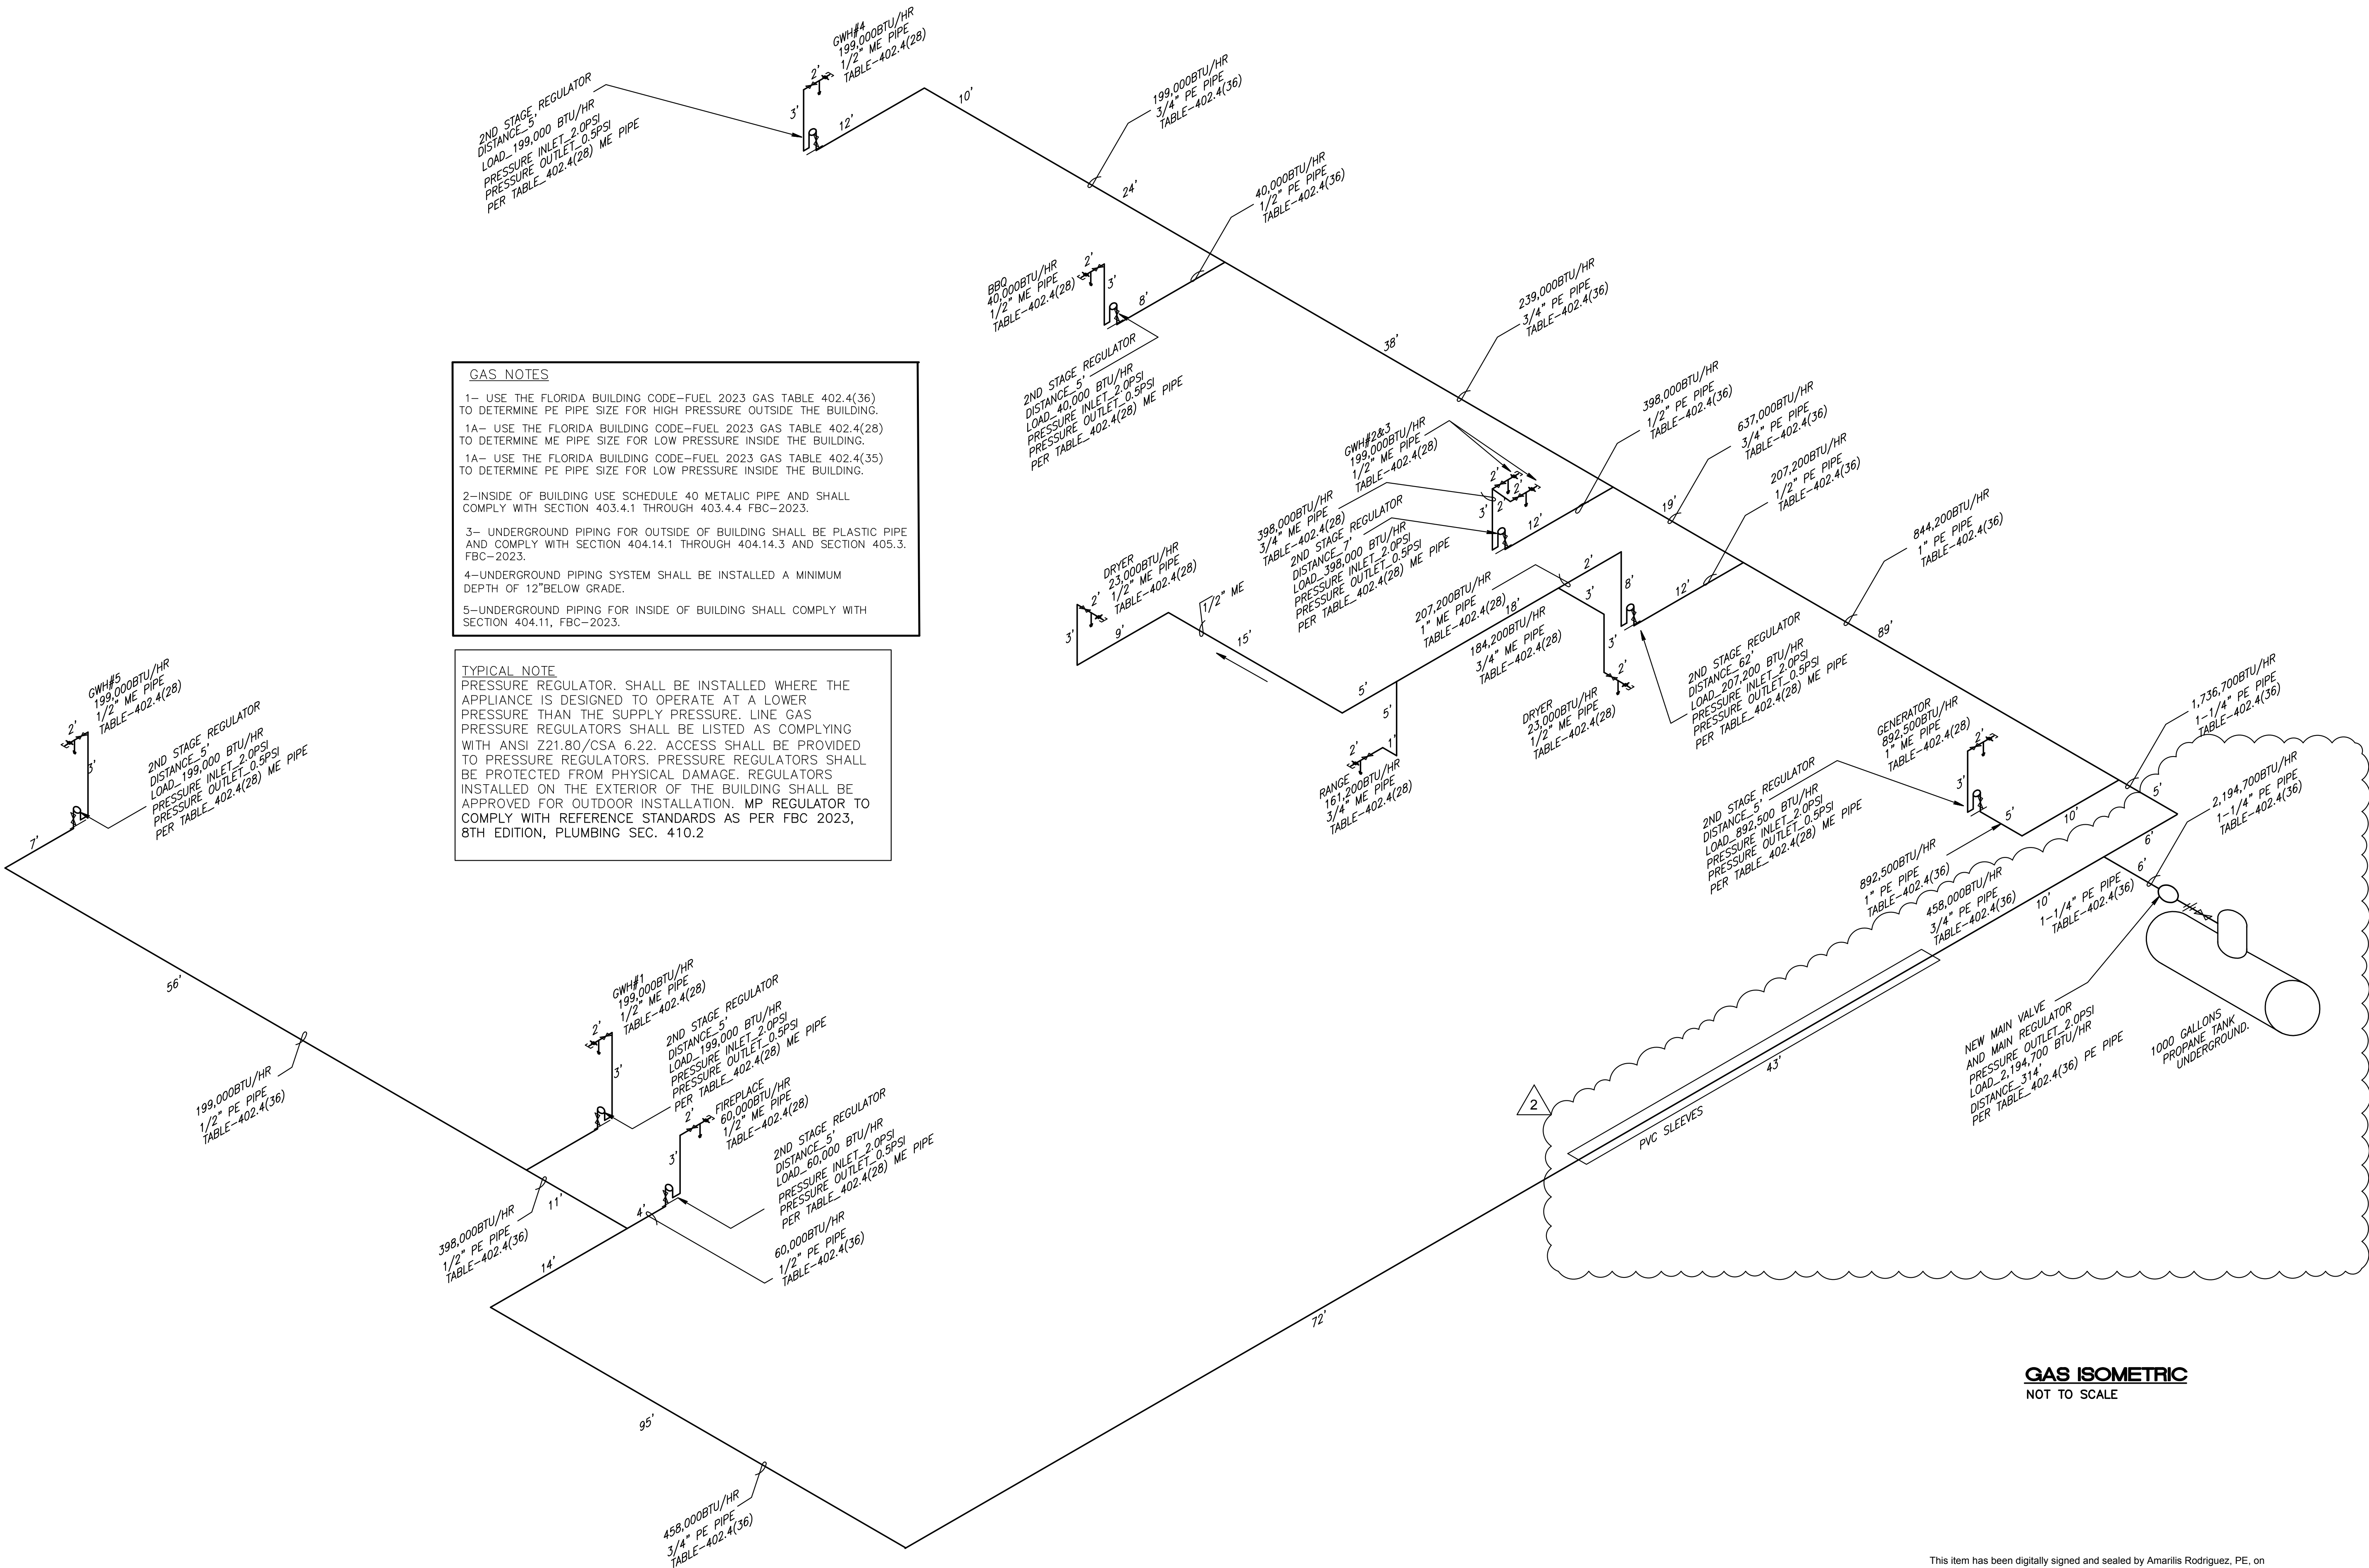

GAS ISOMETRIC
NOT TO SCALE

This Item has been digitally signed and sealed by Amarilis Rodriguez, PE, on
Printed copies of this document are not considered signed and
sealed and the signature must be verified on any electronic copies.

JOB# 24-0407



Amarilis Rodriguez, P.E.
License Number 60236
C.A. 26359

2020 Ponce de Leon Blvd., Suite 1002
Coral Gables, Florida 33134
Phone > 305 444 8809
Fax > 305 444 9827
Engineering Design:
> Mechanical > Electrical
> Plumbing > Fire Protection
www.arpe-eng.com
Signature _____
Date _____